

ALL DIMENSIONS ARE IN MILLIMETRES UNLESS OTHERWISE STATED
DO NOT SCALE FROM THIS DRAWING

Fire Alarm

 CALLPOINT

 SMOKE DETECTOR COMBINED SMOKE DETECTOR/SOUNDER COMBINED HEAT DETECTOR/SOUNDER/BEACON

COMBINED BEACON/SOUNDER W

RIM RELAY INTERFACE MODULE



MAIN FIRE CONTROL PANEL



4 HERMITAGE CLOSE
THREE LEGGED CROSS
WIMBORNE
DORSET
BH21 6QA
Tel: 07835 742300
e-mail: antony@antonyclinton.co.uk

Email: autocad_drawings@btinternet.com

Project:

Title:

Drawn By:

ISW

Checked By:

Date:

FEB 16

Date:

Date: FEB 16

© This drawing and/or design is the property of 'LIFE SAFETY SYSTEMS' and shall not be reproduced or copied in the whole or part in any way or conveyed to a third party without the owners written permission.

Drawing Number:

SAMPLE/2016/02/FA100

Revision:

--	--	--	--	--	--	--	--


THE LAYOUTS AS DEPICTED HAVE BEEN DIRECTLY EXTRAPOLATED FROM EXISTING PAPER LAYOUT BUILDING PLANS
AS A CONSEQUENCE THE BUILDING CONFIGURATIONS AS SHOWN MAY NOT BE COMPLETELY ACCURATE OR CORRECTLY SCALED

ALL DIMENSIONS ARE IN MILLIMETRES UNLESS OTHERWISE STATED
DO NOT SCALE FROM THIS DRAWING

A1

Fire Alarm

- CALLPOINT
- SMOKE DETECTOR
- COMBINED SMOKE DETECTOR/SOUNDER
- COMBINED HEAT DETECTOR/SOUNDER/BEACON
- COMBINED BEACON/SOUNDER WALL MOUNTED
- RELAY INTERFACE MODULE
- MAIN FIRE CONTROL PANEL

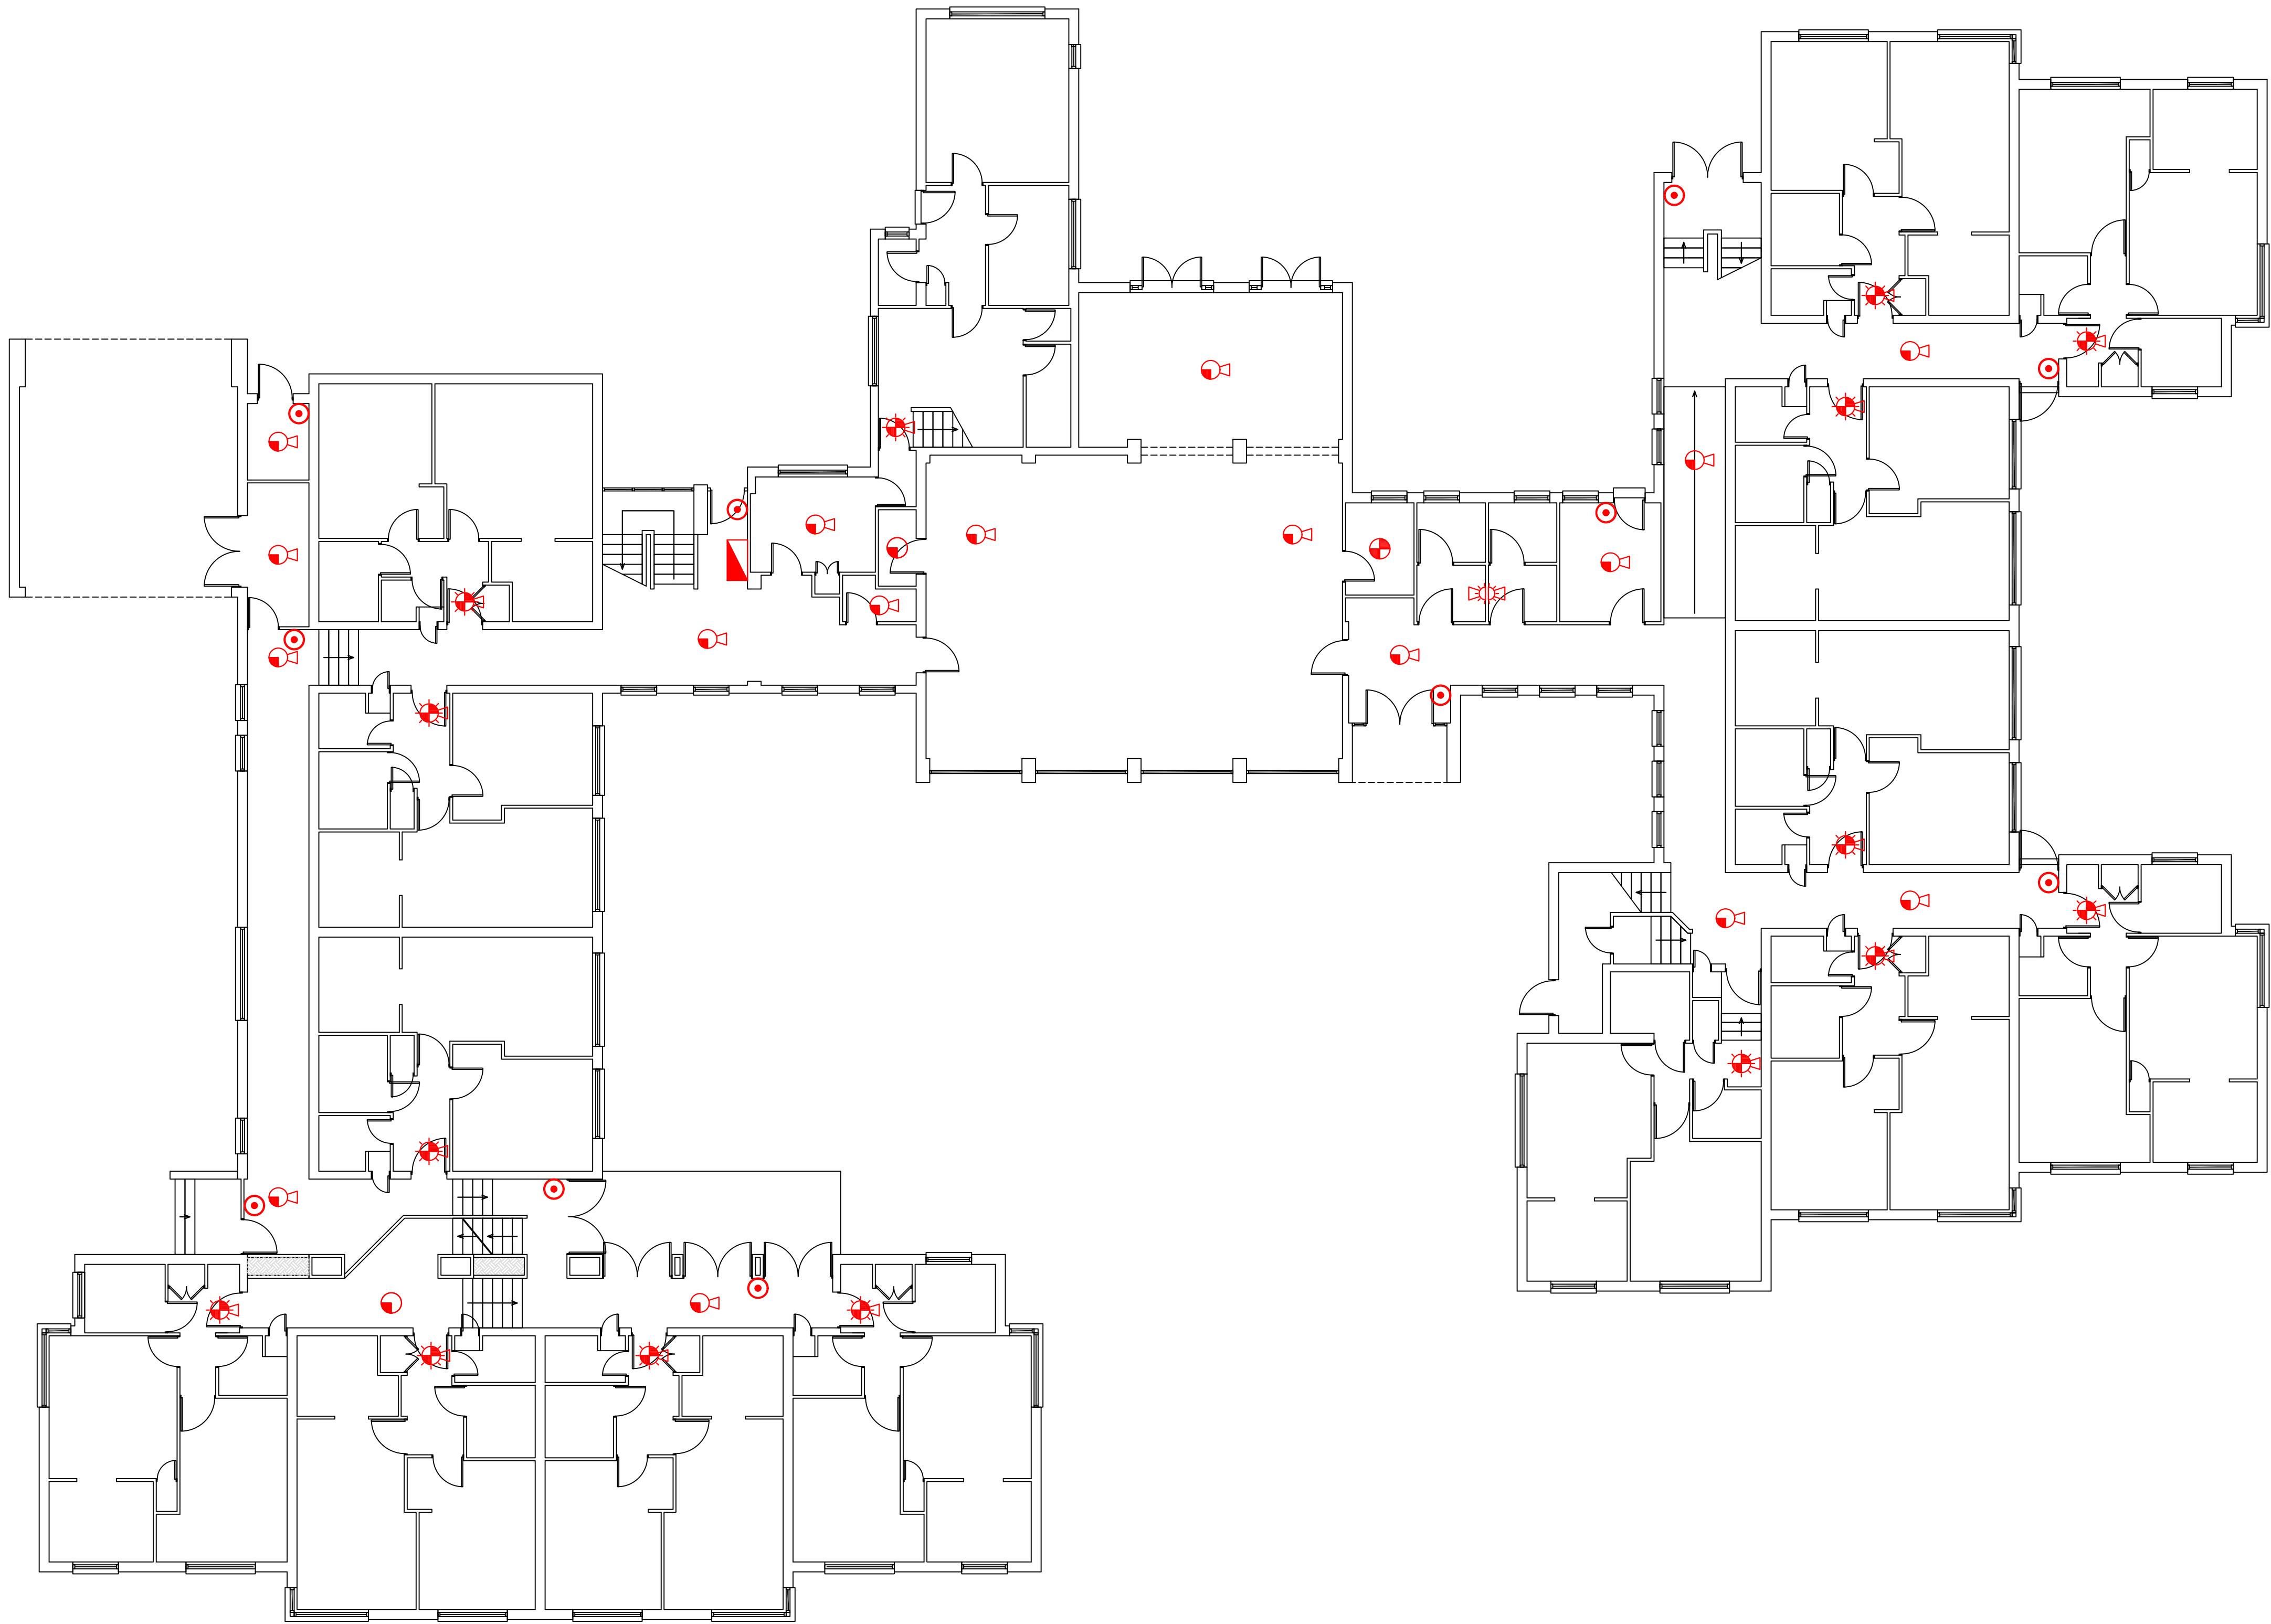

NOTES:



4 HERMITAGE CLOSE
THREE LEGGED CROSS
WIMBORNE
DORSET
BH21 6QA
Tel: 07835 742300
Email: autocad_drawings@btinternet.com

Revision	Description	Date	Checked
AMENDMENT RECORD			

Project:
Evans Williams Court
Whitcombe Road
Carisbrooke
Newport
Isle of Wight
PO30 1EB

Title:
Proposed
Fire Alarm System
(BS5839:Part 1)
SHARED & COMMUNAL AREAS
GROUND FLOOR

Drawn By:
ISW
Checked By:
Scale @ A1:
1:100

Date:
FEB 16
Date:
FEB 16

© This drawing and/or design is the property of 'LIFE SAFETY SYSTEMS' and shall not be reproduced or copied in the whole or part in any way or conveyed to a third party without the owners written permission.
Drawing Number:
SAMPLE/2016/02/FA110
Revision:

-  CALLPOINT
-  SMOKE DETECTOR
-  COMBINED SMOKE DETECTOR/SOUNDER
-  COMBINED HEAT DETECTOR/SOUNDER/BEACON
-  COMBINED BEACON/SOUNDER WALL MOUNTED
-  RELAY INTERFACE MODULE
-  MAIN FIRE CONTROL PANEL



4 HERMITAGE CLOSE
THREE LEGGED CROSS
WIMBORNE
DORSET
BH21 6QA
Tel: 07835 742300
autocad_drawings@btinternet.com

Revision	Description	Date	Checked
AMENDMENT RECORD			

Project:
Evans Williams Court
Whitcombe Road
Carisbrooke
Newport
Isle of Wight
PO30 1EB

Title:

**Proposed
Fire Alarm System
(BS5839:Part 1)**

**SHARED & COMMUNAL AREAS
FIRST FLOOR**

Drawn By: ISW

Date: **FEB 16**

Checked By:

Date:

Scale @ A1:
1:100

Date: FEB 16

© This drawing and/or design is the property of 'LIFE SAFETY SYSTEMS' and shall not be reproduced or copied in the whole or part in any way or conveyed to a third party without the owners written permission.

Drawing Number:

SAMPLE/2016/02/FA120

Revision:								
-----------	--	--	--	--	--	--	--	--

Fire Alarm

-
- This is a floor plan of a building with a complex, irregular shape. The plan shows various rooms, corridors, and a staircase. A red icon of a person is placed in the central corridor area. The building's footprint is defined by a black outline.



Revision	Description	Date	Checked
AMENDMENT RECORD			

Title:

**Proposed
Fire Alarm System
(BS5839:Part 6)**

**RESIDENTIAL FLATS
BASEMENT**

© This drawing and/or design is the property of 'LIFE SAFETY SYSTEMS' and shall not be reproduced or copied in the whole or part in any way or conveyed to a third party without the owners written permission.

Drawing Number:

Date: **FEB 16**


Drawing Number:

SAMPLE/2016/02/FA600

Revision:								
-----------	--	--	--	--	--	--	--	--

Fire Alarm

-  HUSH BUTTON
-  MAINS/BATTERY SMOKE DETECTOR/SOUNDER
-  MAINS/BATTERY HEAT DETECTOR/SOUNDER

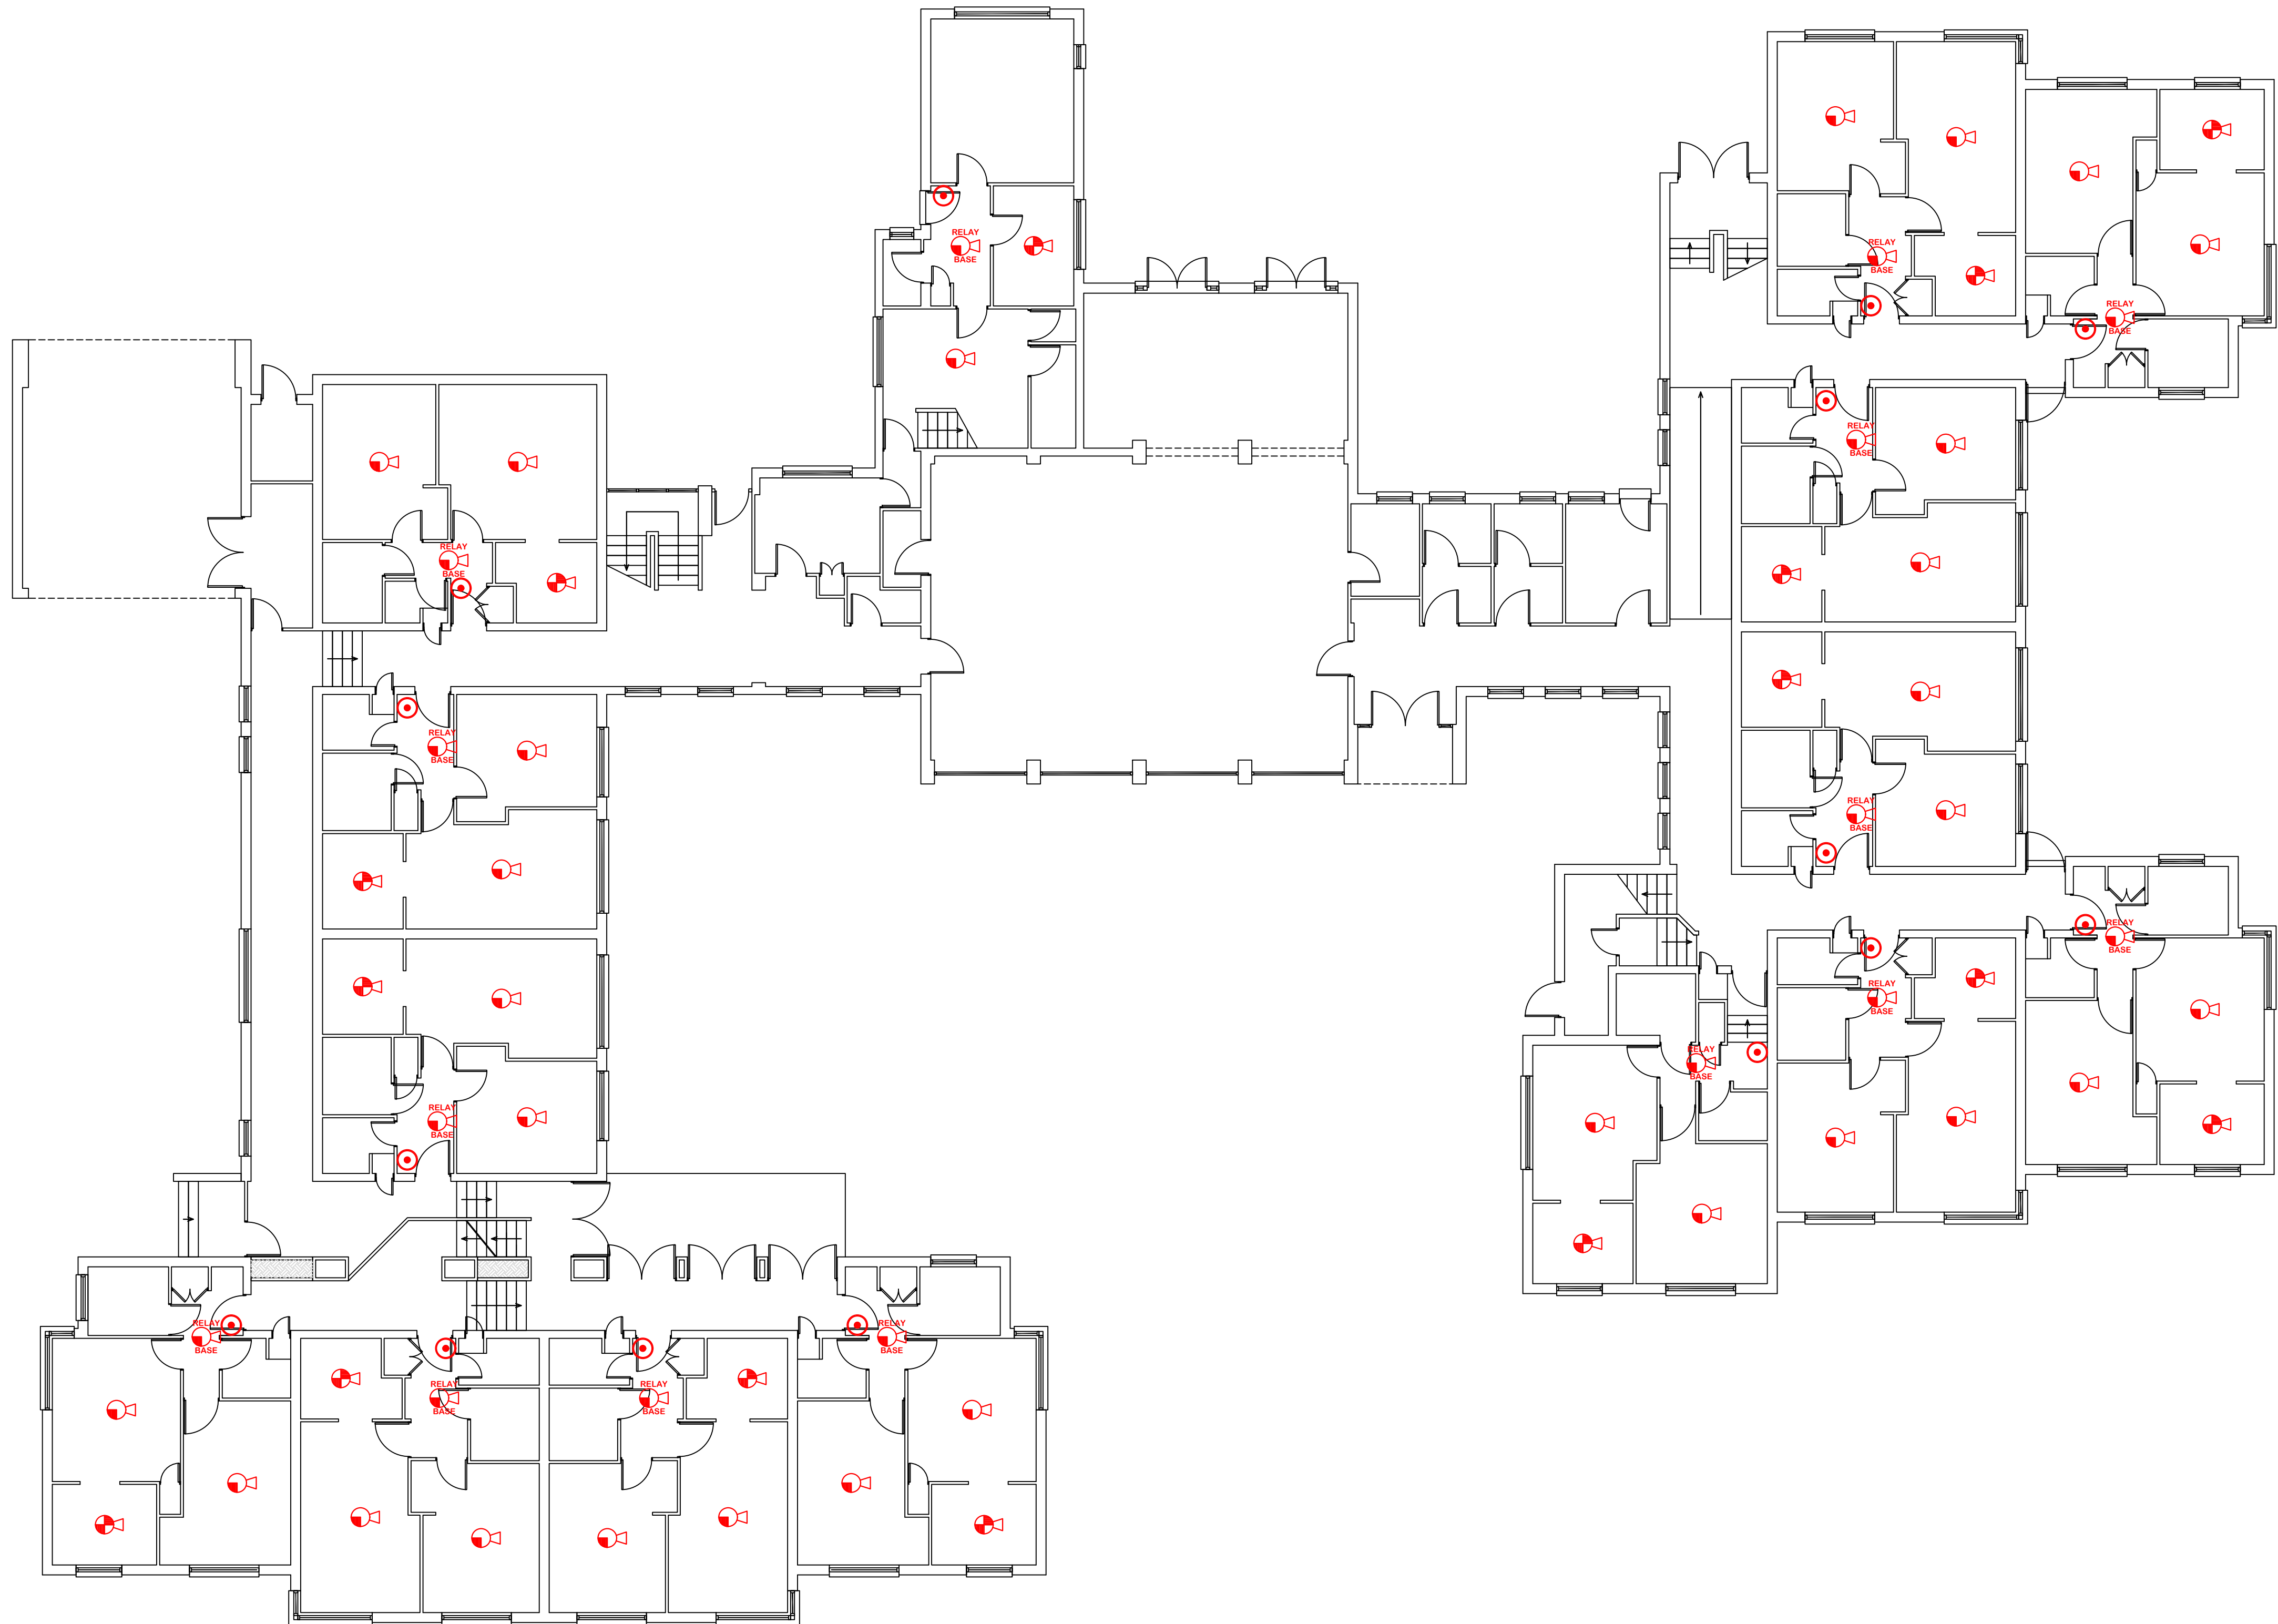

4 HERMITAGE CLOSE
THREE LEGGED CROSS
WIMBORNE
DORSET
BH21 6QA
Tel: 07835 742300
autocad_drawings@btinternet.com

Revision	Description	Date	Checked
AMENDMENT RECORD			

Project:

**Evans Williams Court
Whitcombe Road
Carisbrooke
Newport
Isle of Wight
PO30 1EB**

Title:

**Proposed
Fire Alarm System
(BS5839:Part 6)**

**RESIDENTIAL FLATS
GROUND FLOOR**

Drawn By: **ISW**

FEB 16

Checked By:

Date:

Scale @ A1:
1:100

FEB 16

© This drawing and/or design is the property of 'LIFE SAFETY SYSTEMS' and shall not be reproduced or copied in the whole or part in any way or conveyed to a third party without the owners written permission.

Drawing Number:

SAMPLE/2016/02/FA610

Revision:


THE LAYOUTS AS DEPICTED HAVE BEEN DIRECTLY EXTRAPOLATED FROM EXISTING PAPER LAYOUT BUILDING PLANS
AS A CONSEQUENCE THE BUILDING CONFIGURATIONS AS SHOWN MAY NOT BE COMPLETELY ACCURATE OR CORRECTLY SCALED

ALL DIMENSIONS ARE IN MILLIMETRES UNLESS OTHERWISE STATED
DO NOT SCALE FROM THIS DRAWING

A1

Fire Alarm

-  CALLPOINT
-  SMOKE DETECTOR
-  COMBINED SMOKE DETECTOR/SOUNDER
-  COMBINED HEAT DETECTOR/SOUNDER/BEACON
-  COMBINED BEACON/SOUNDER WALL MOUNTED
-  RELAY INTERFACE MODULE
-  MAIN FIRE CONTROL PANEL

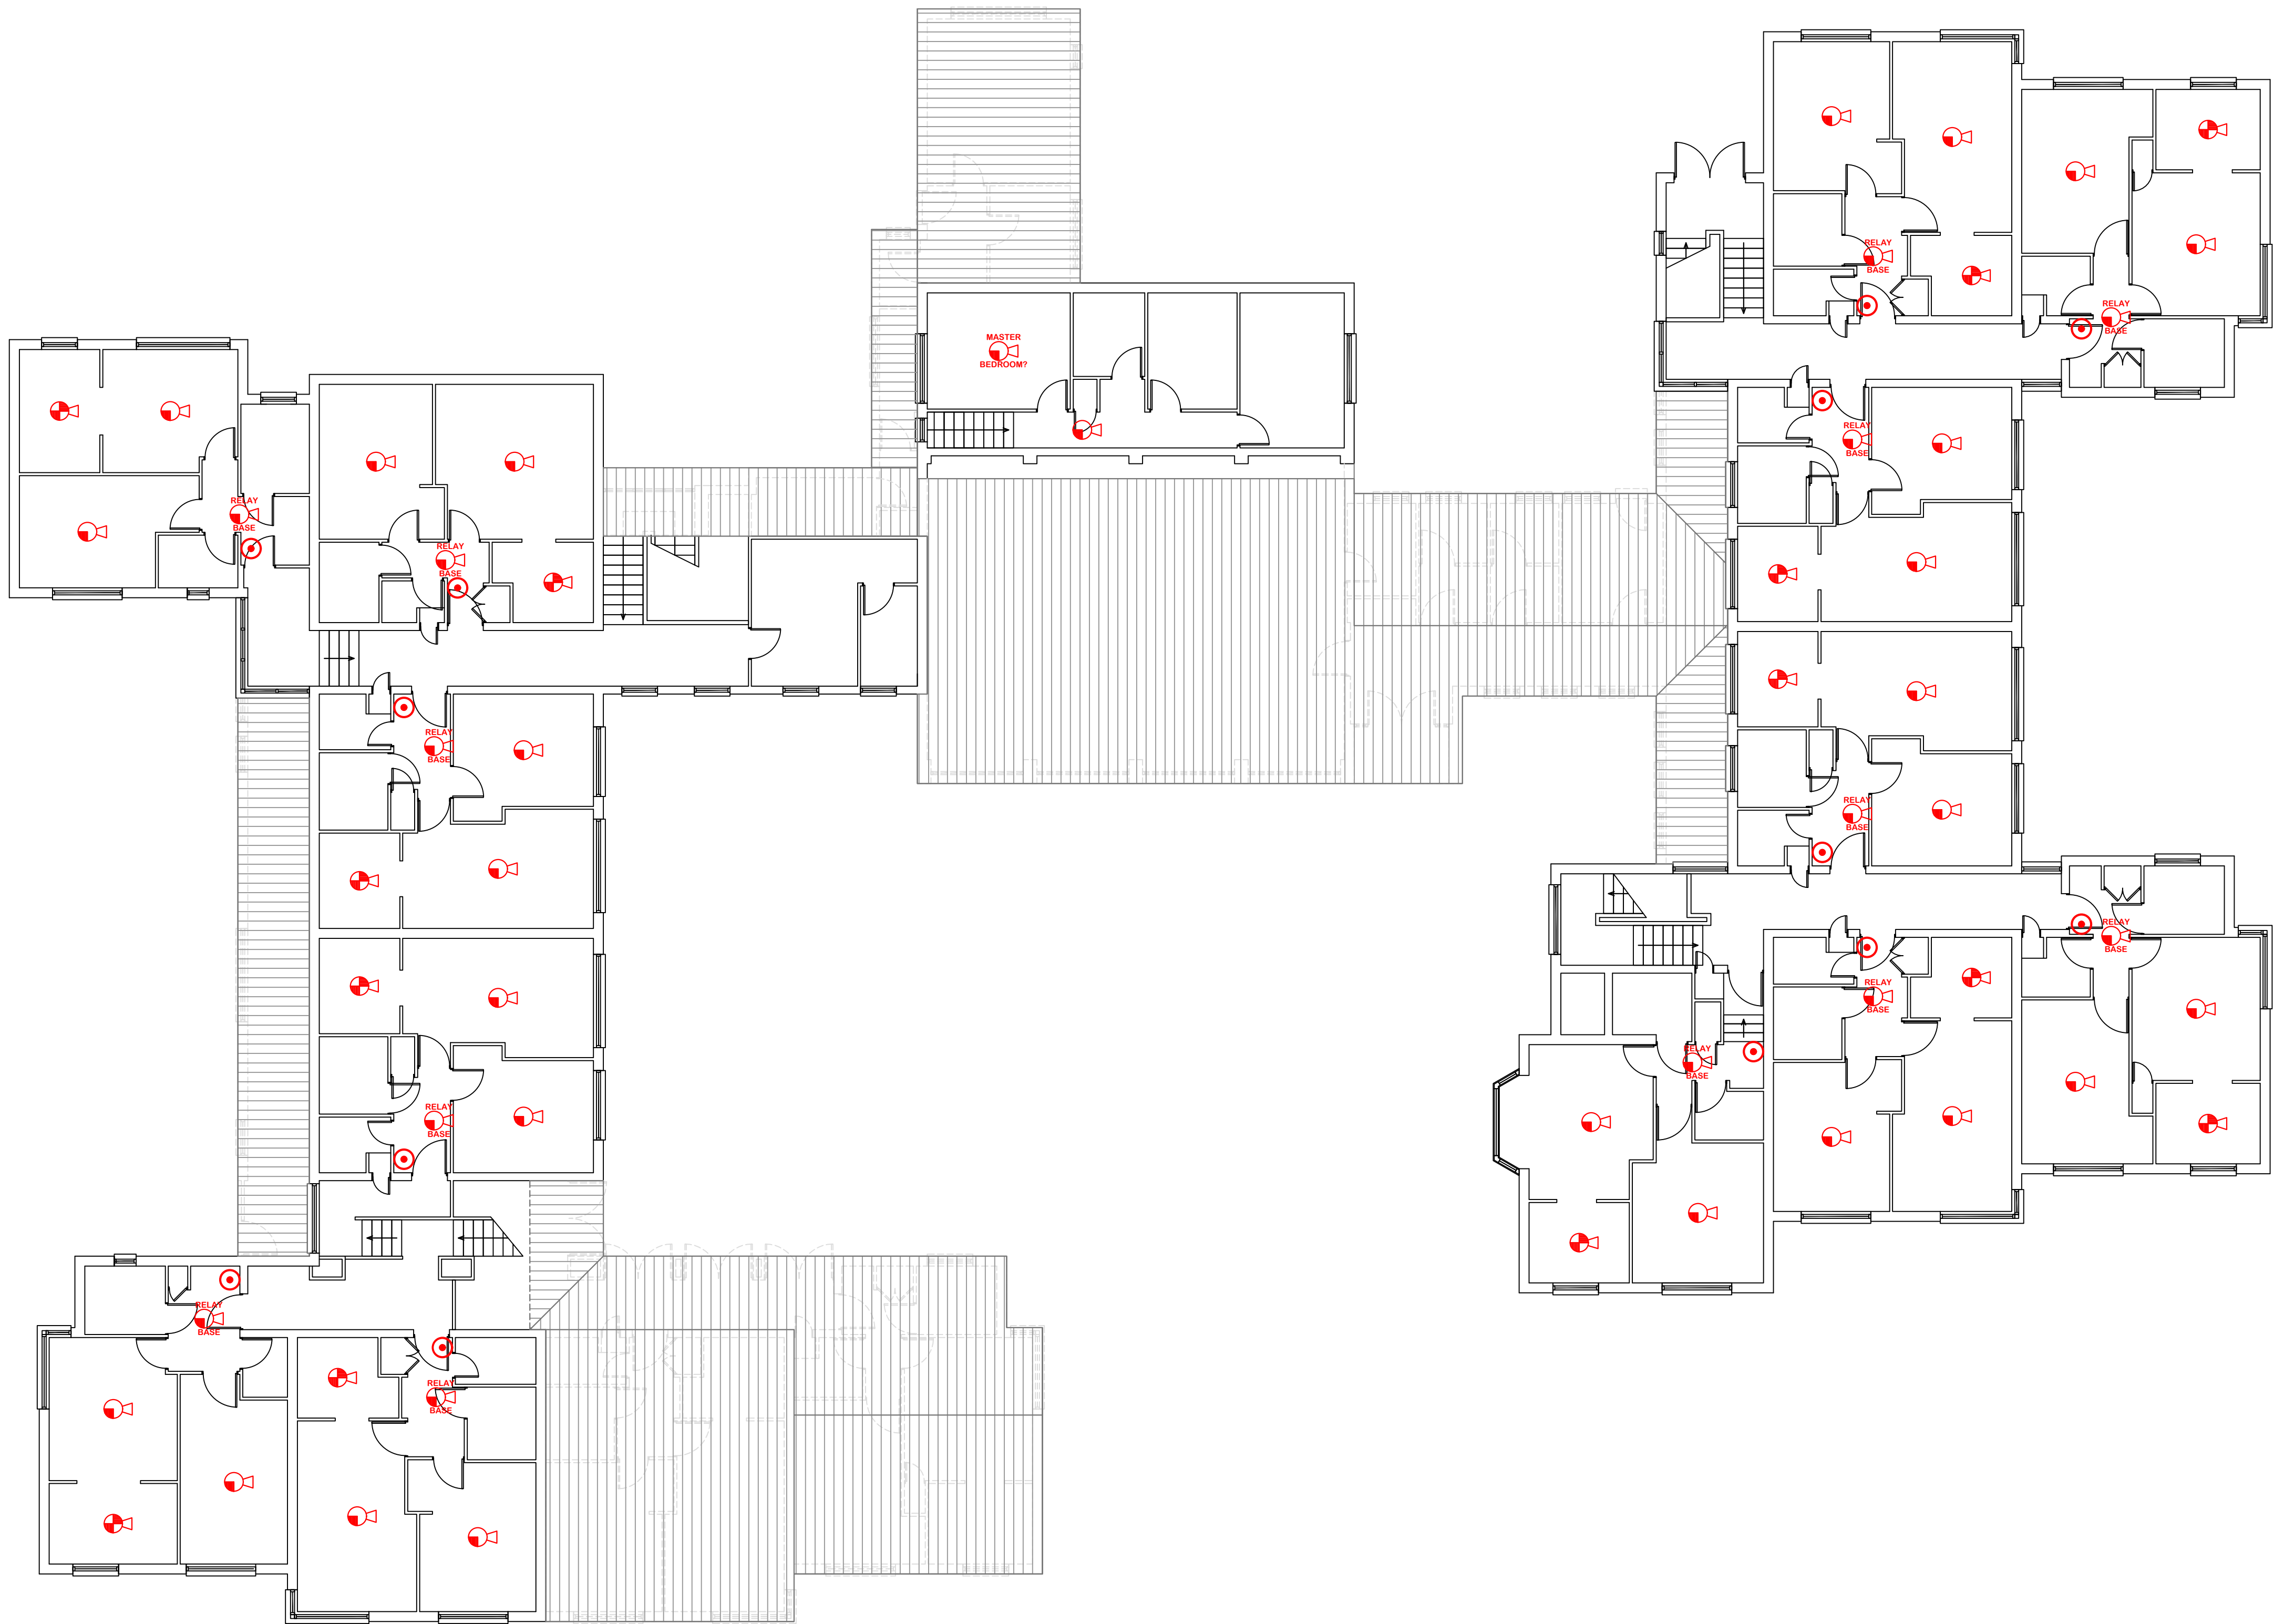

NOTES:



4 HERMITAGE CLOSE
THREE LEGGED CROSS
WIMBORNE
DORSET
BH21 6QA
Tel: 07835 742300
Email: autocad_drawings@btinternet.com

Revision	Description	Date	Checked
AMENDMENT RECORD			

Project:
Evans Williams Court
Whitcombe Road
Carisbrooke
Newport
Isle of Wight
PO30 1EB

Title:
Proposed
Fire Alarm System
(BS5839:Part 6)
RESIDENTIAL FLATS
FIRST FLOOR

Drawn By:
ISW
Checked By:
Scale @ A1:
1:100

Date:
FEB 16
Date:
FEB 16

© This drawing and/or design is the property of 'LIFE SAFETY SYSTEMS' and shall not be reproduced or copied in the whole or part in any way or conveyed to a third party without the owners written permission.
Drawing Number:
SAMPLE/2016/02/FA620
Revision: