


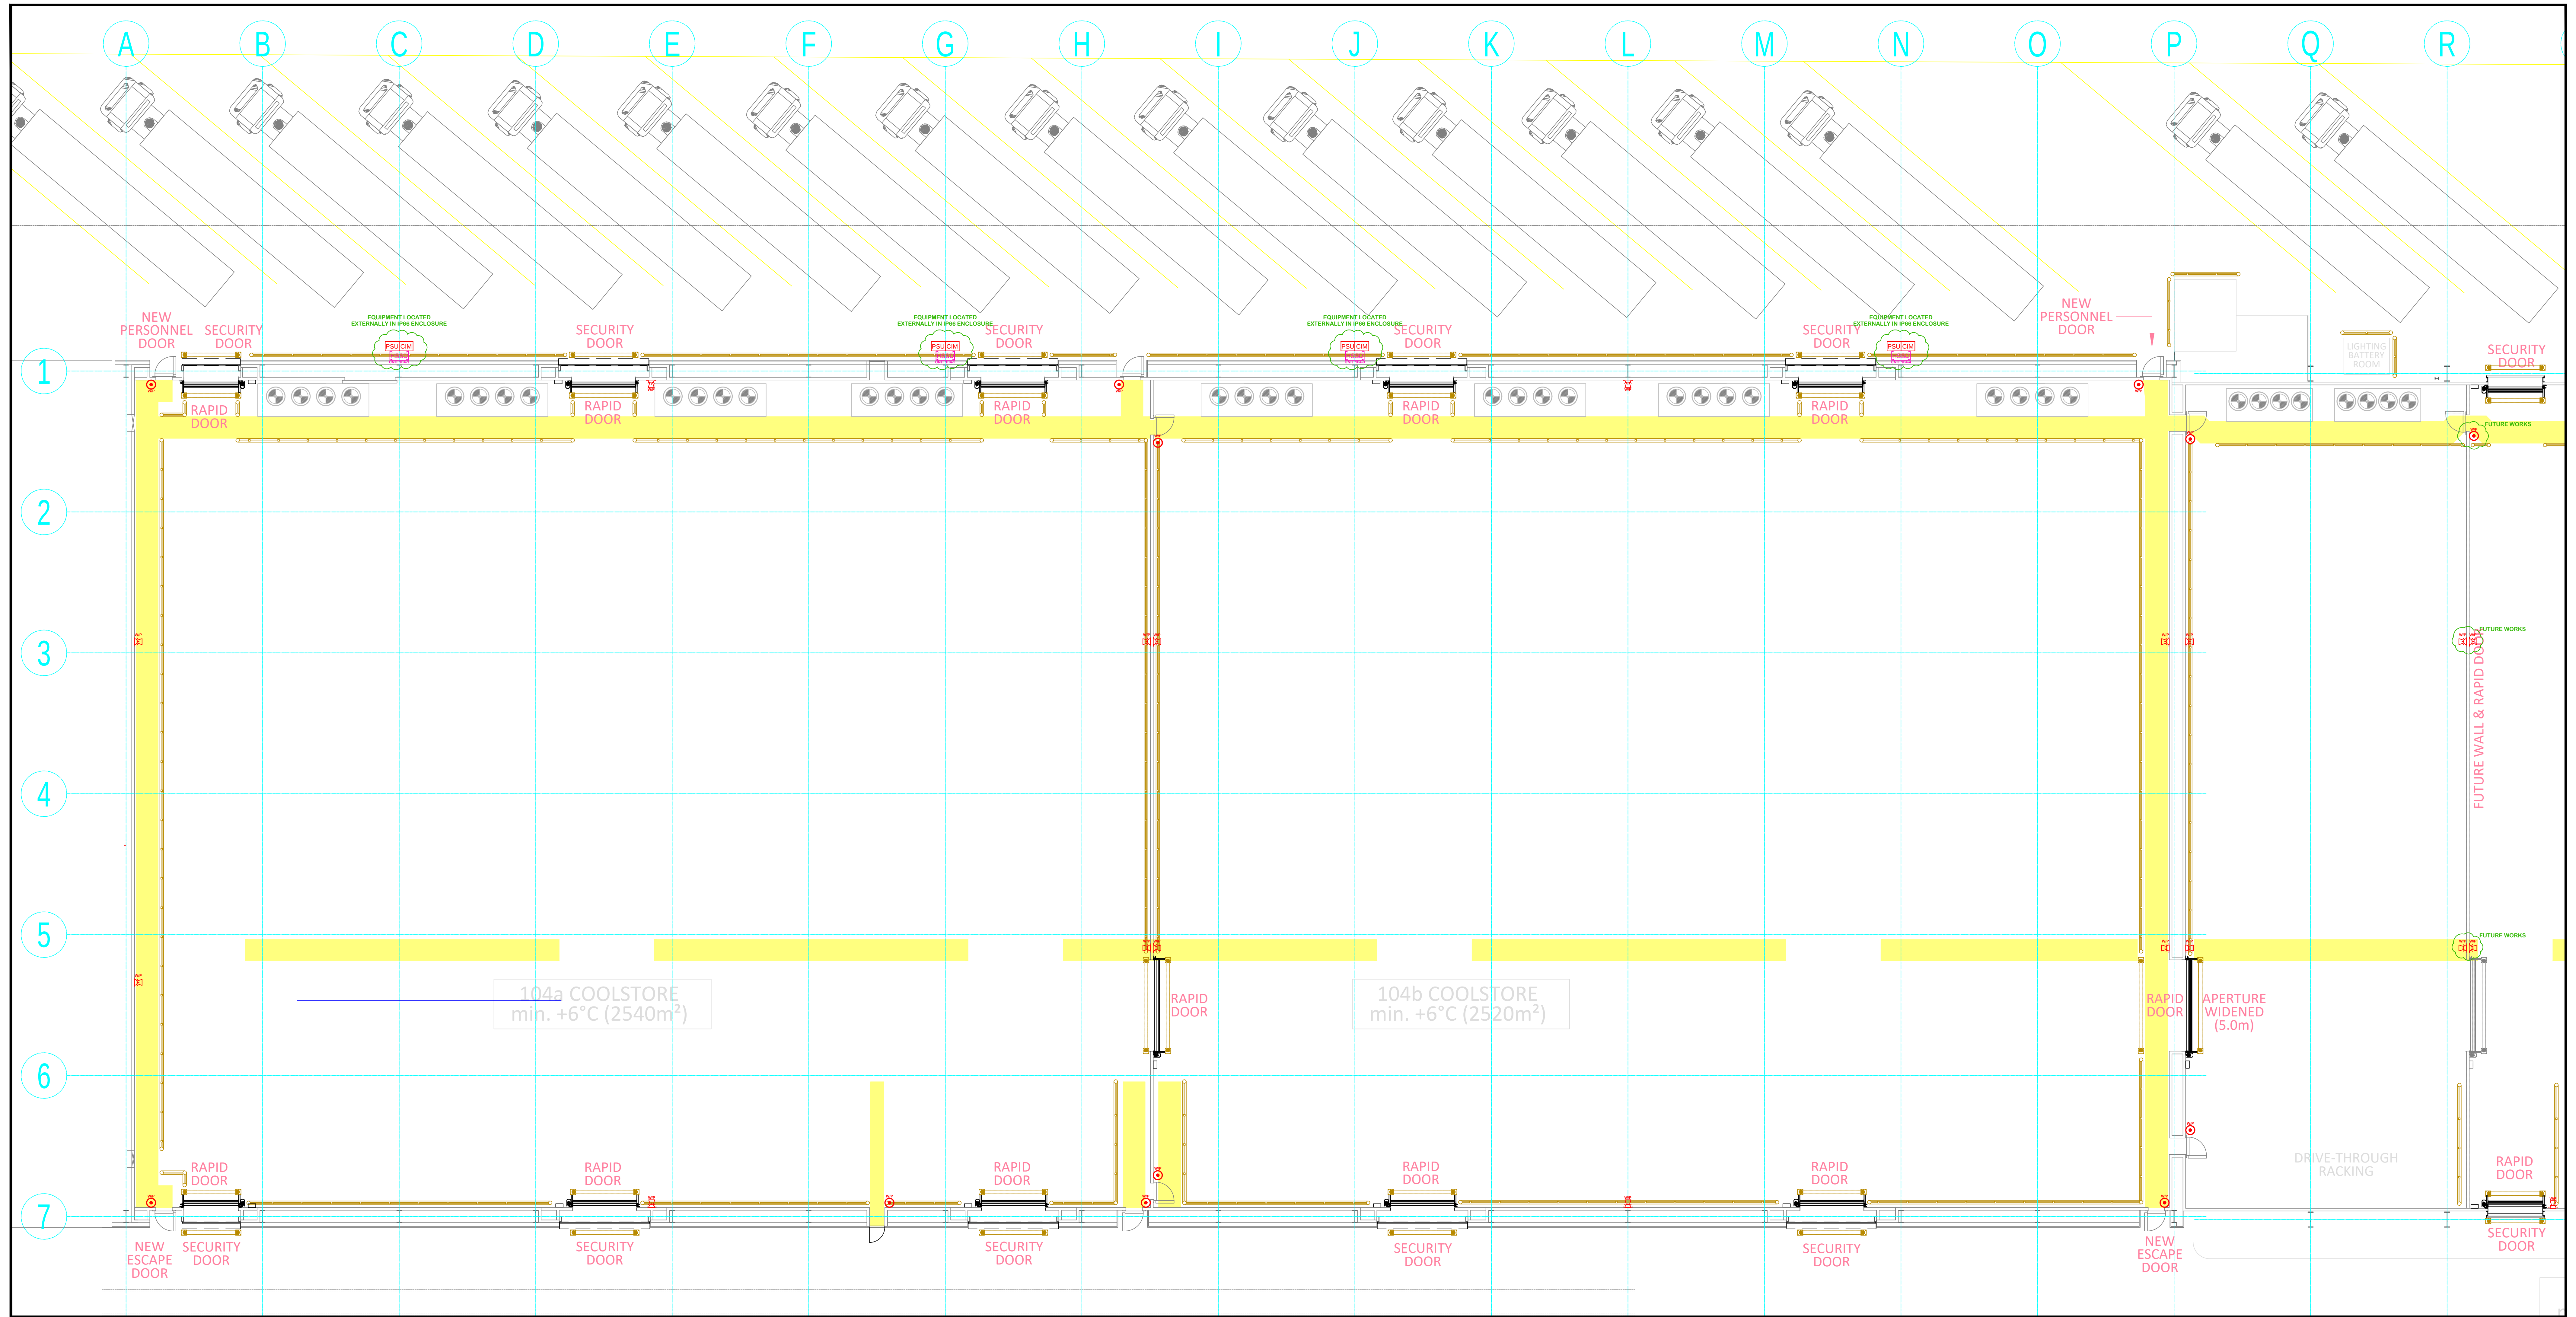

Fire Alarm

- CALLPOINT
- IONISATION SMOKE DETECTOR
- SMOKE DETECTOR
- FLAME DETECTOR
- CARBON DIOXIDE DETECTOR
- GAS DETECTOR
- HEAT DETECTOR


- COMBINED SMOKE DETECTOR/SOUNDER
- COMBINED HEAT DETECTOR/SOUNDER
- COMBINED SMOKE DETECTOR/SOUNDER/BEACON
- COMBINED HEAT DETECTOR/SOUNDER/BEACON
- COMBINED SMOKE DETECTOR/BEACON
- COMBINED HEAT DETECTOR/BEACON
- ALARM BELL

- ELECTRONIC SOUNDER
- ELECTRONIC SOUNDER WP - WEATHER PROOF
- COMBINED SMOKE DETECTOR/SOUNDER WITH LINE ISOLATOR
- FLASHING BEACON CEILING MOUNTED
- FLASHING BEACON WALL MOUNTED
- COMBINED BEACON/SOUNDER CEILING MOUNTED
- COMBINED BEACON/SOUNDER WALL MOUNTED

- L.E.D REMOTE INDICATOR
- LINE ISOLATOR
- CABLING JUNCTION BOX
- TEE BREAKER
- RELAY INTERFACE MODULE
- CONTACT INPUT MODULE
- DETECTOR INPUT MODULE

- SOUNDER NOTIFICATION MODULE
- SOUNDER CIRCUIT END OF LINE RESISTOR
- BEAM SMOKE DETECTOR AND ANALYSER
- BEAM REFLECTOR
- BEAM SMOKE DETECTOR TRANSMITTER
- 24v POWER SUPPLY UNIT
- MAIN FIRE CONTROL PANEL

- FIRE CONTROL REPEATER PANEL
- ELECTRICAL DISTRIBUTION BOARD
- HIGH SENSITIVITY SMOKE DETECTION CONTROL UNIT (VESDA)
- MAGNETIC DOOR HOLDER
- OVER DOOR HOLDER/CLOSURE

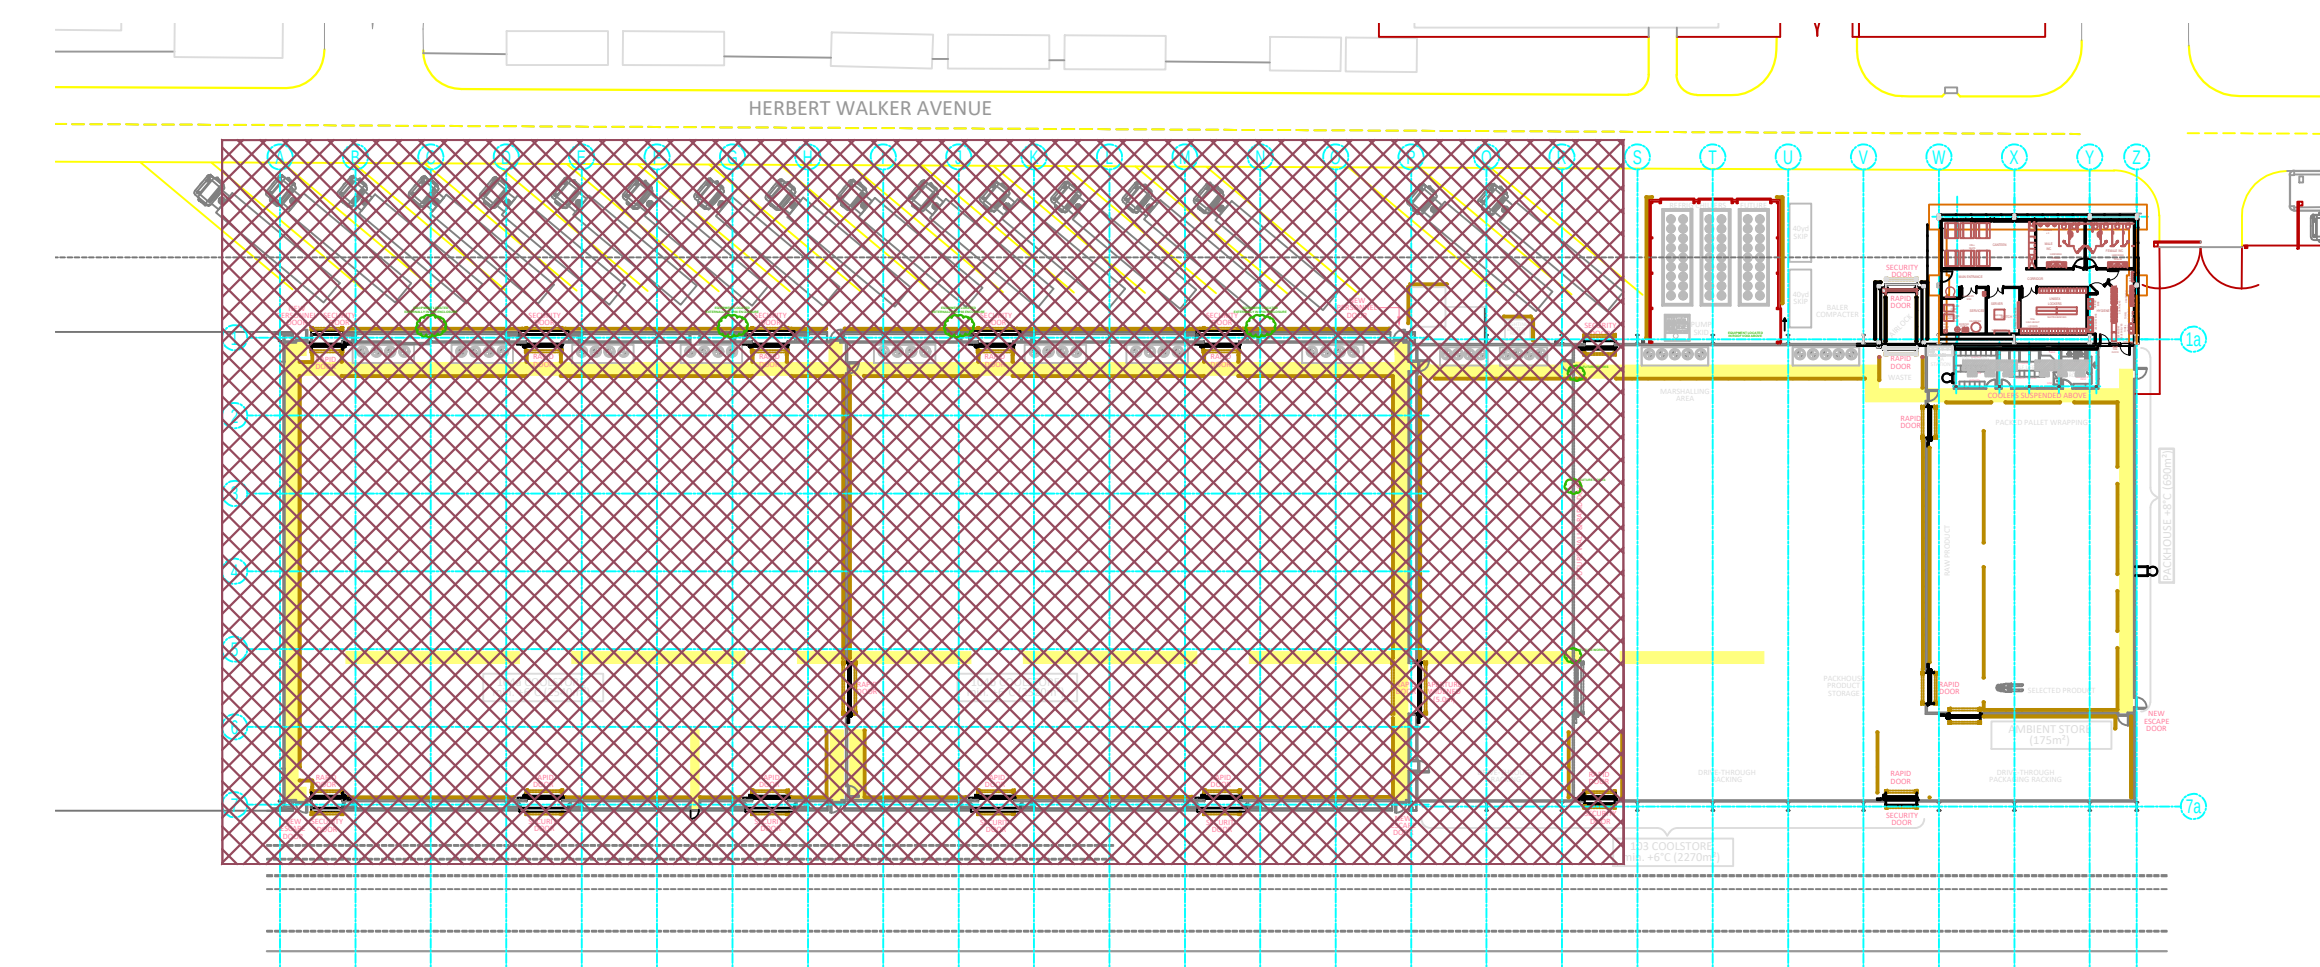

NOTES:



4 HERMITAGE CLOSE
THREE LEGGED CROSS
WIMBORNE
DORSET
BH21 1QA
Tel: 01203 742300
Email: info@lifesystems.co.uk

Revision	Description	Date	Checked
AMENDMENT RECORD			

Project:
ABP - Canary Fruit Terminal
Berth 103 & 104
Western Docks
Southampton
Hampshire

Title:
New Tomato Warehouse / Shed
Proposed
Fire Alarm System
GROUND FLOOR
(Sheet 1 of 2)

Drawn By: ISW
Checked By:
Scale @ A0: 1:125
Date: AUG 16

Drawing Number:
SAMPLE/2016/08/FA101
Revision:



Fire Alarm

- CAL
- ION
- SMO
- FLA
- CAR
- GAS
- HEA

- | | |
|---|--|
|  | COMBINED SMOKE DETECTOR/SOUNDER |
|  | COMBINED HEAT DETECTOR/SOUNDER |
|  | COMBINED SMOKE DETECTOR/SOUNDER/BEACON |
|  | COMBINED HEAT DETECTOR/SOUNDER/BEACON |
|  | COMBINED SMOKE DETECTOR/BEACON |
|  | COMBINED HEAT DETECTOR/BEACON |
|  | ALARM BELL |

-  ELECTRONIC SOUNDER
-  ELECTRONIC SOUNDER WP = WEATHER PROOF
-  COMBINED SMOKE DETECTOR/SOUNDER
WITH LINE ISOLATOR
-  FLASHING BEACON CEILING MOUNTED
-  FLASHING BEACON WALL MOUNTED
-  COMBINED BEACON/SOUNDER CEILING MOUNTED
-  COMBINED BEACON/SOUNDER WALL MOUNTED

- | | |
|---|------------------------|
|  | L.E.D REMOTE INDICATOR |
|  | LINE ISOLATOR |
|  | CABLING JUNCTION BOX |
|  | TEE BREAKER |
|  | RELAY INTERFACE MODULE |
|  | CONTACT INPUT MODULE |
|  | DETECTOR INPUT MODULE |

- | | |
|---|--------------------------------------|
|  | SOUNDER NOTIFICATION MODULE |
|  | SOUNDER CIRCUIT END OF LINE RESISTOR |
|  | BEAM SMOKE DETECTOR AND ANALYSER |
|  | BEAM REFLECTOR |
|  | BEAM SMOKE DETECTOR TRANSMITTER |
|  | 24v POWER SUPPLY UNIT |
|  | MAIN FIRE CONTROL PANEL |

- | | |
|---|--|
|  | FIRE CONTROL REPEATER PANEL |
|  | ELECTRICAL DISTRIBUTION BOARD |
|  | HIGH SENSITIVITY SMOKE DETECTION
CONTROL UNIT (VESDA) |
|  | MAGNETIC DOOR HOLDER |
|  | OVER DOOR HOLDER/CLOSURE |

NOTES:



4 HERMITAGE CLOSE
THREE LEGGED CROSS
WIMBORNE
DORSET
BH21 6QA
Tel: 07835 742300
Email: autocad_drawings@btinternet.com

Revision	Description	Date	Checked
AMENDMENT RECORD			

Project:
**ABP - Canary Fruit Terminal
Berth 103 & 104
Western Docks
Southampton
Hampshire**

Title:
**New Tomato Warehouse / Shed
Proposed
Fire Alarm System**

GROUND FLOOR

(Sheet 2 of 2)

Drawn By: ISW	Date: AUG 16
Checked By:	Date:
Scale @ A0: 1:125	Date: AUG 16



© This drawing and/or design is the property of 'LIFE SAFETY SYSTEMS' and shall not be reproduced or copied in the whole or part in any way or conveyed to a third party without the owners written permission.

Drawing Number:

SAMPLE/2016/08/FA102

Revision:

--	--	--	--	--	--	--

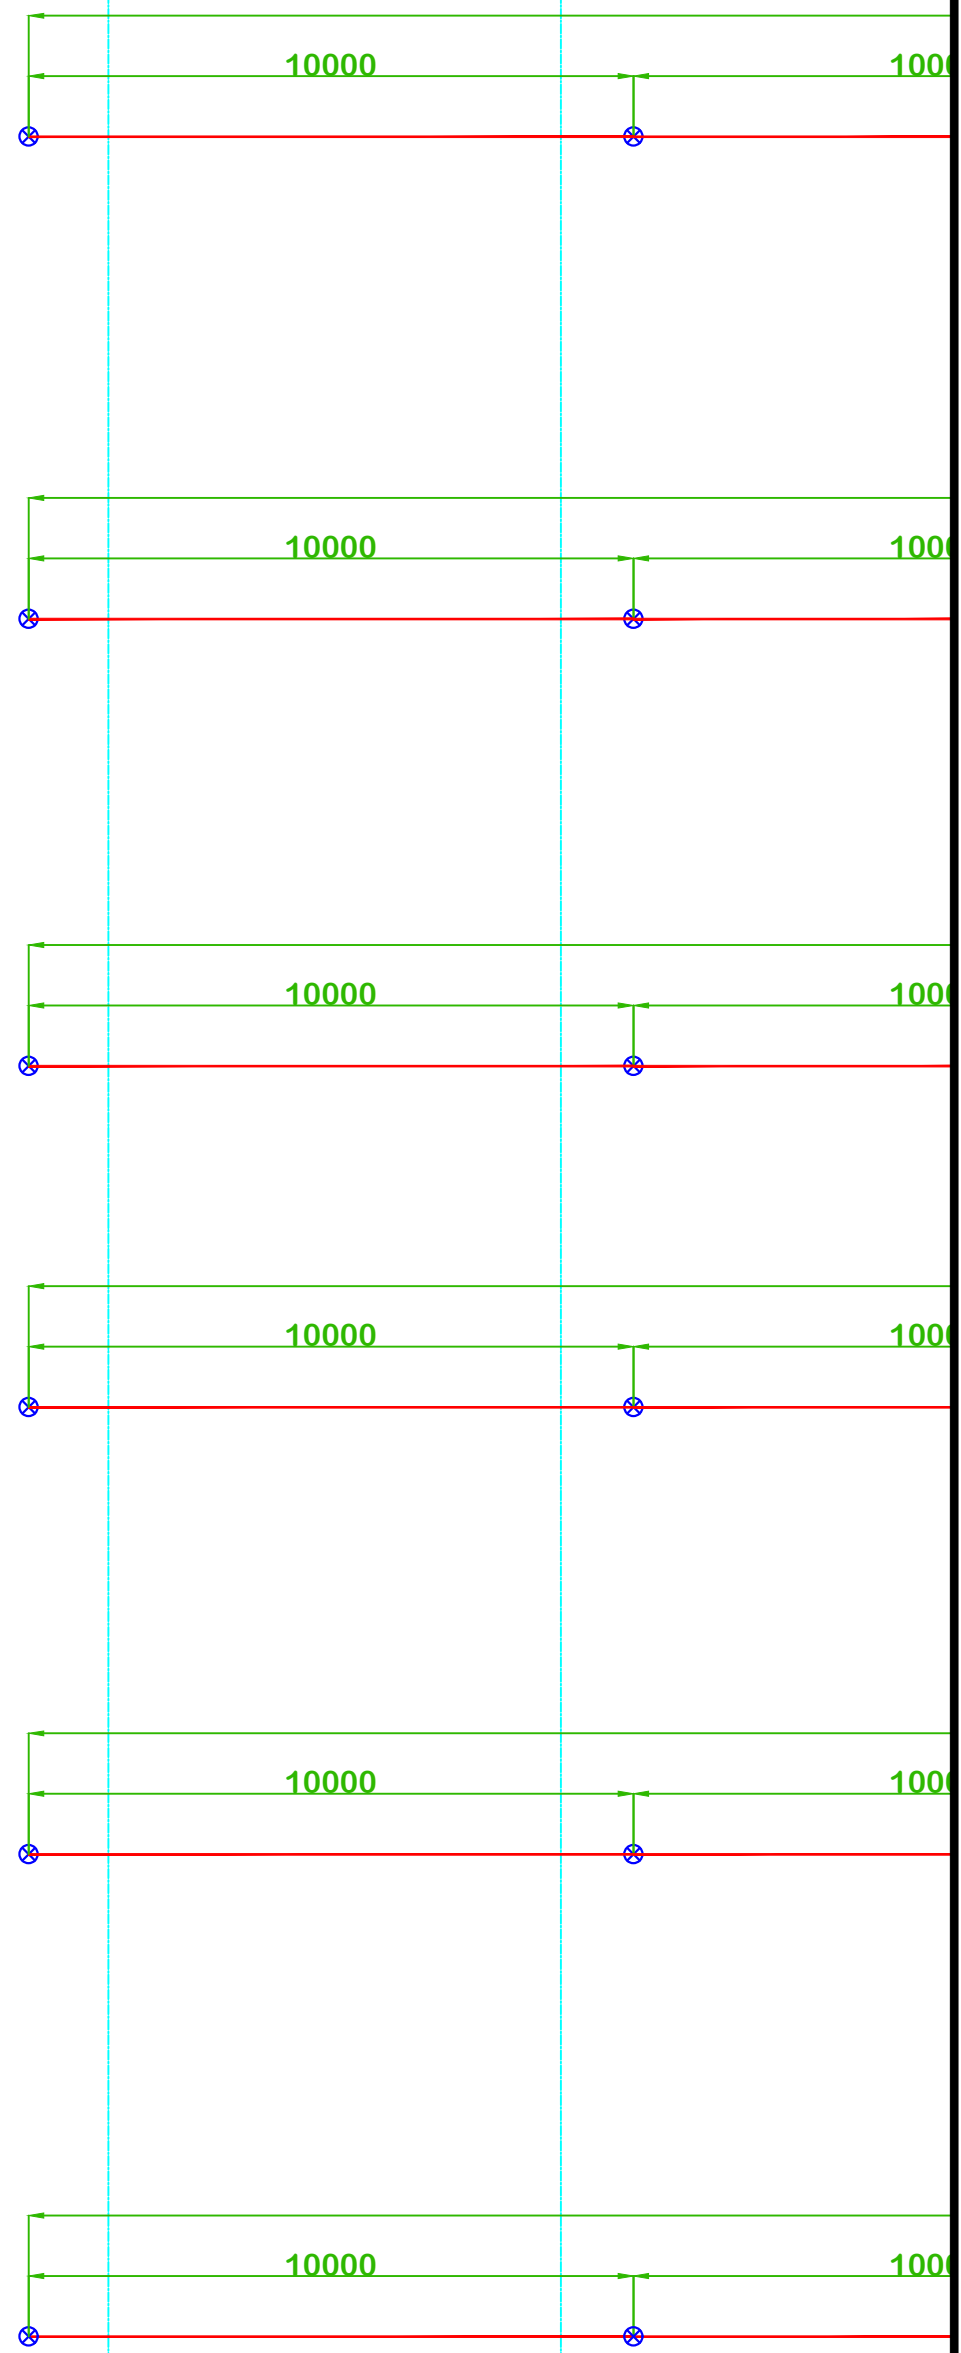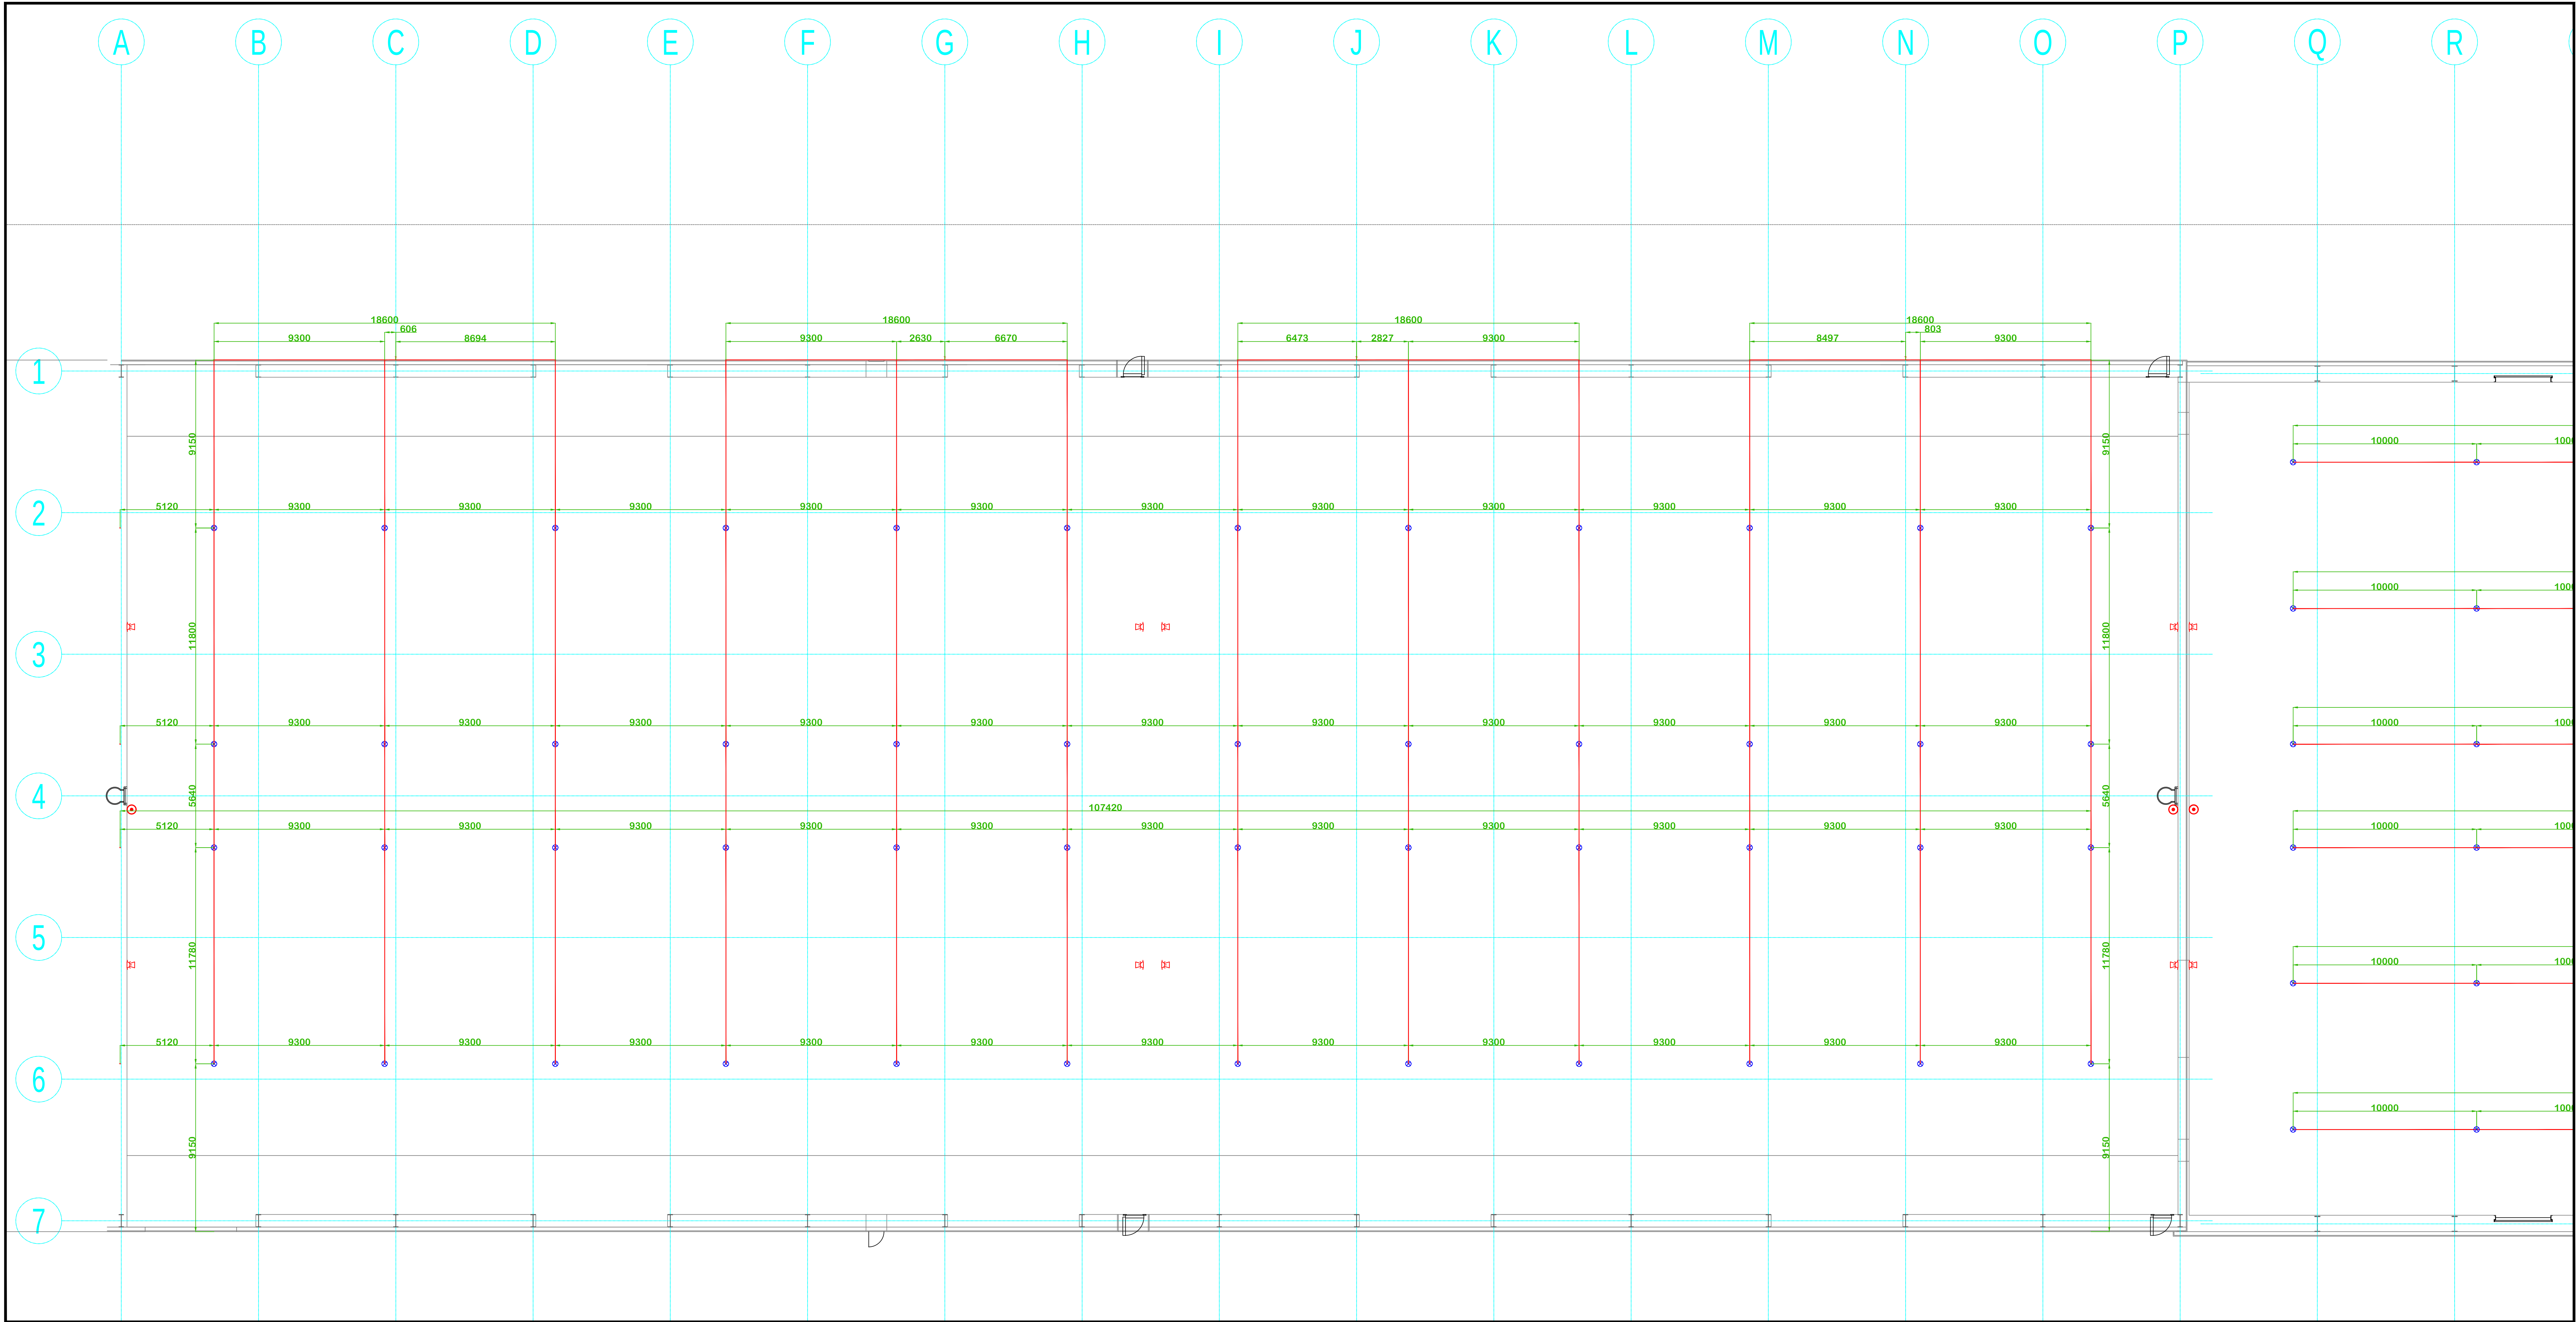

Fire Alarm

- CALLPOINT
- IONISATION SMOKE DETECTOR
- SMOKE DETECTOR
- FLAME DETECTOR
- CARBON DIOXIDE DETECTOR
- GAS DETECTOR
- HEAT DETECTOR

- COMBINED SMOKE DETECTOR/SOUNDER
- COMBINED HEAT DETECTOR/SOUNDER
- COMBINED SMOKE DETECTOR/SOUNDER/BEACON
- COMBINED HEAT DETECTOR/SOUNDER/BEACON
- COMBINED SMOKE DETECTOR/BEACON
- COMBINED HEAT DETECTOR/BEACON
- ALARM BELL

- ELECTRONIC SOUNDER
- ELECTRONIC SOUNDER WP - WEATHER PROOF
- COMBINED SMOKE DETECTOR/SOUNDER WITH LINE ISOLATOR
- FLASHING BEACON CEILING MOUNTED
- FLASHING BEACON WALL MOUNTED
- COMBINED BEACON/SOUNDER CEILING MOUNTED
- COMBINED BEACON/SOUNDER WALL MOUNTED

- L.E.D REMOTE INDICATOR
- LINE ISOLATOR
- CABLING JUNCTION BOX
- TEE BREAKER
- RELAY INTERFACE MODULE
- CONTACT INPUT MODULE
- DETECTOR INPUT MODULE

- SOUNDER NOTIFICATION MODULE
- SOUNDER CIRCUIT END OF LINE RESISTOR
- BEAM SMOKE DETECTOR AND ANALYSER
- BEAM REFLECTOR
- BEAM SMOKE DETECTOR TRANSMITTER
- 24v POWER SUPPLY UNIT
- MAIN FIRE CONTROL PANEL

- FIRE CONTROL REPEATER PANEL
- ELECTRICAL DISTRIBUTION BOARD
- HIGH SENSITIVITY SMOKE DETECTION CONTROL UNIT (VESDA)
- MAGNETIC DOOR HOLDER
- OVER DOOR HOLDER/CLOSURE

NOTES:



4 HERMITAGE CLOSE
THREE LEGGED CROSS
WIMBORNE
DORSET
BH21 1QA
Tel: 01783 742300
Email: autocad_drawings@lifesystems.com

Revision	Description	Date	Checked
AMENDMENT RECORD			


Project:
ABP - Canary Fruit Terminal
Berth 103 & 104
Western Docks
Southampton
Hampshire


Title:
New Tomato Warehouse / Shed
Proposed
Fire Alarm System
ROOF VOID
(Sheet 1 of 2)

Drawn By: ISW
Checked By:
Scale @ A0: 1:125
Date: AUG 16

Date: AUG 16
Drawing Number: SAMPLE/2016/08/FA111
Revision:

--	--	--	--	--	--	--	--	--	--

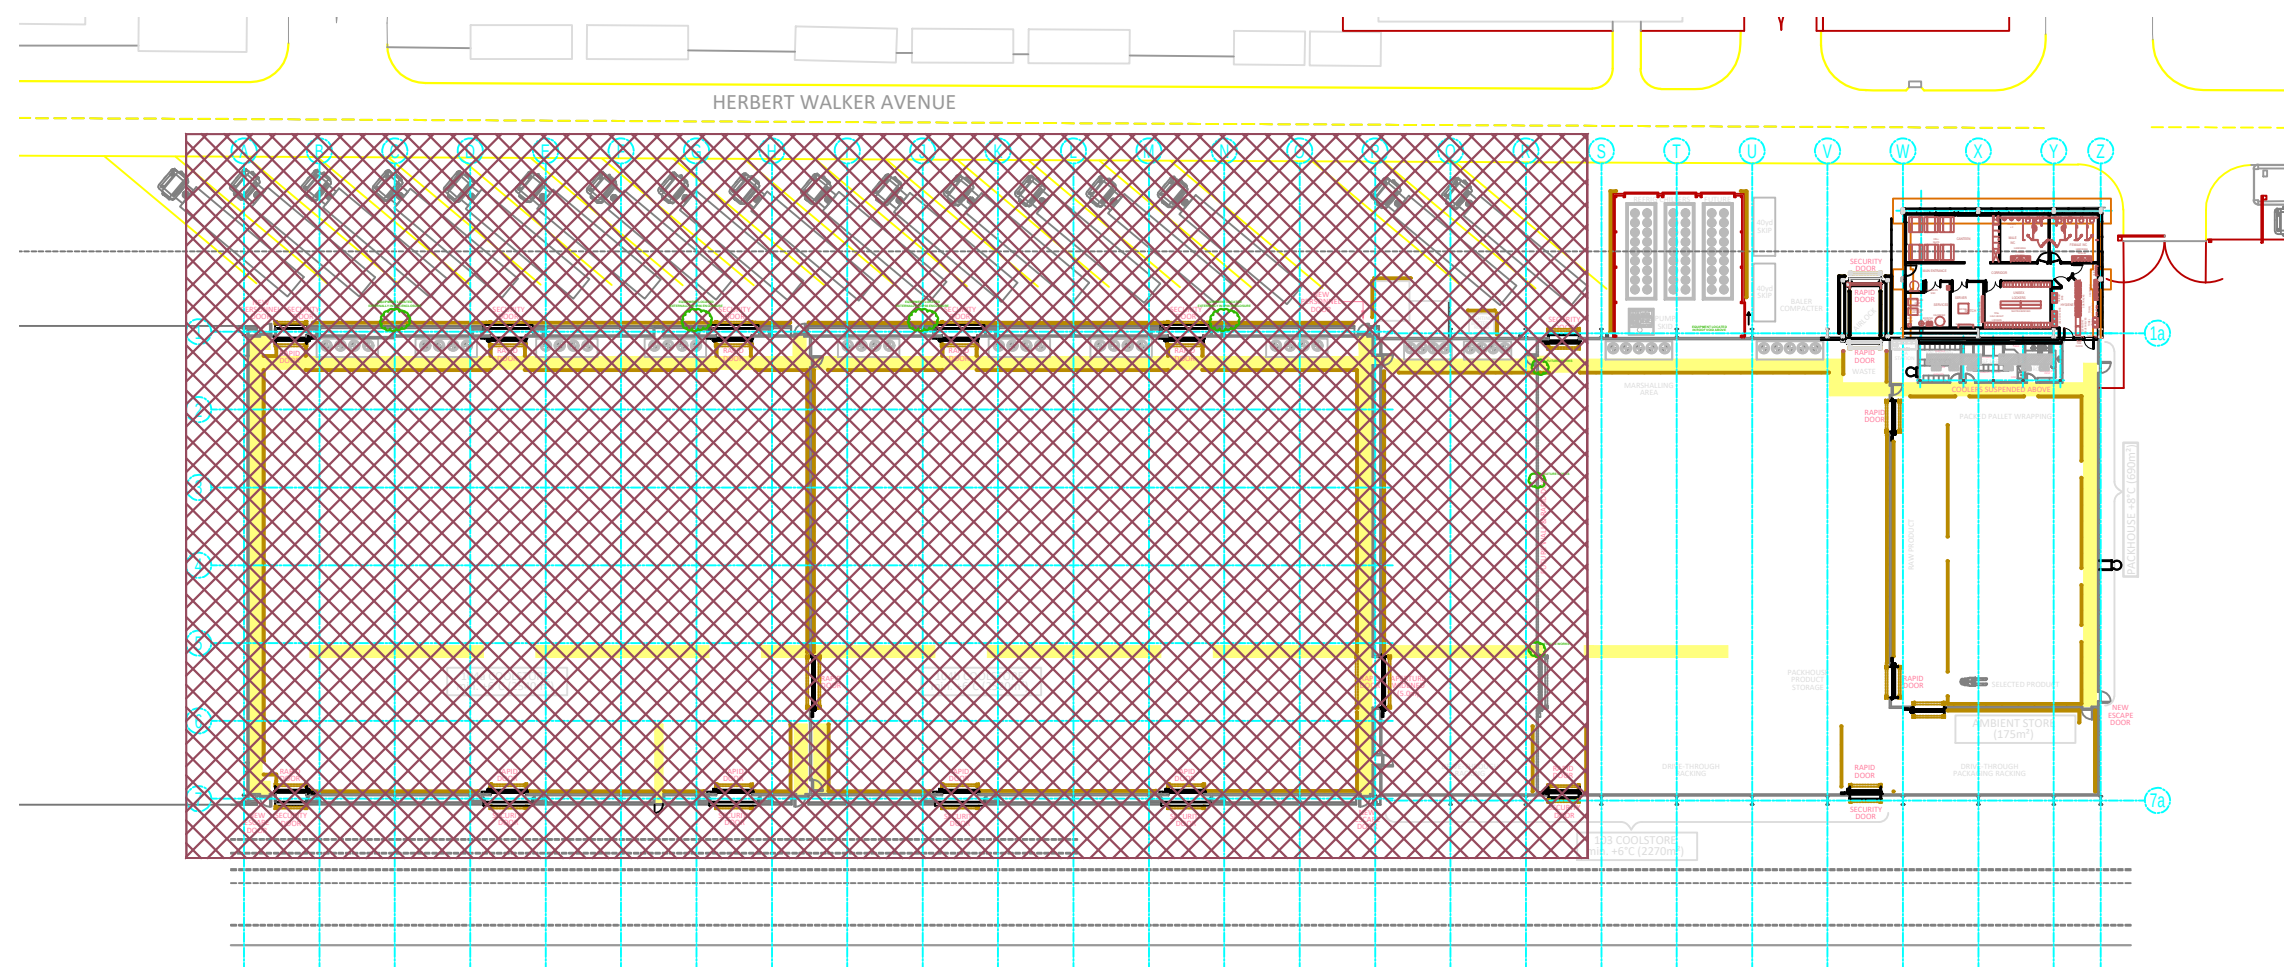

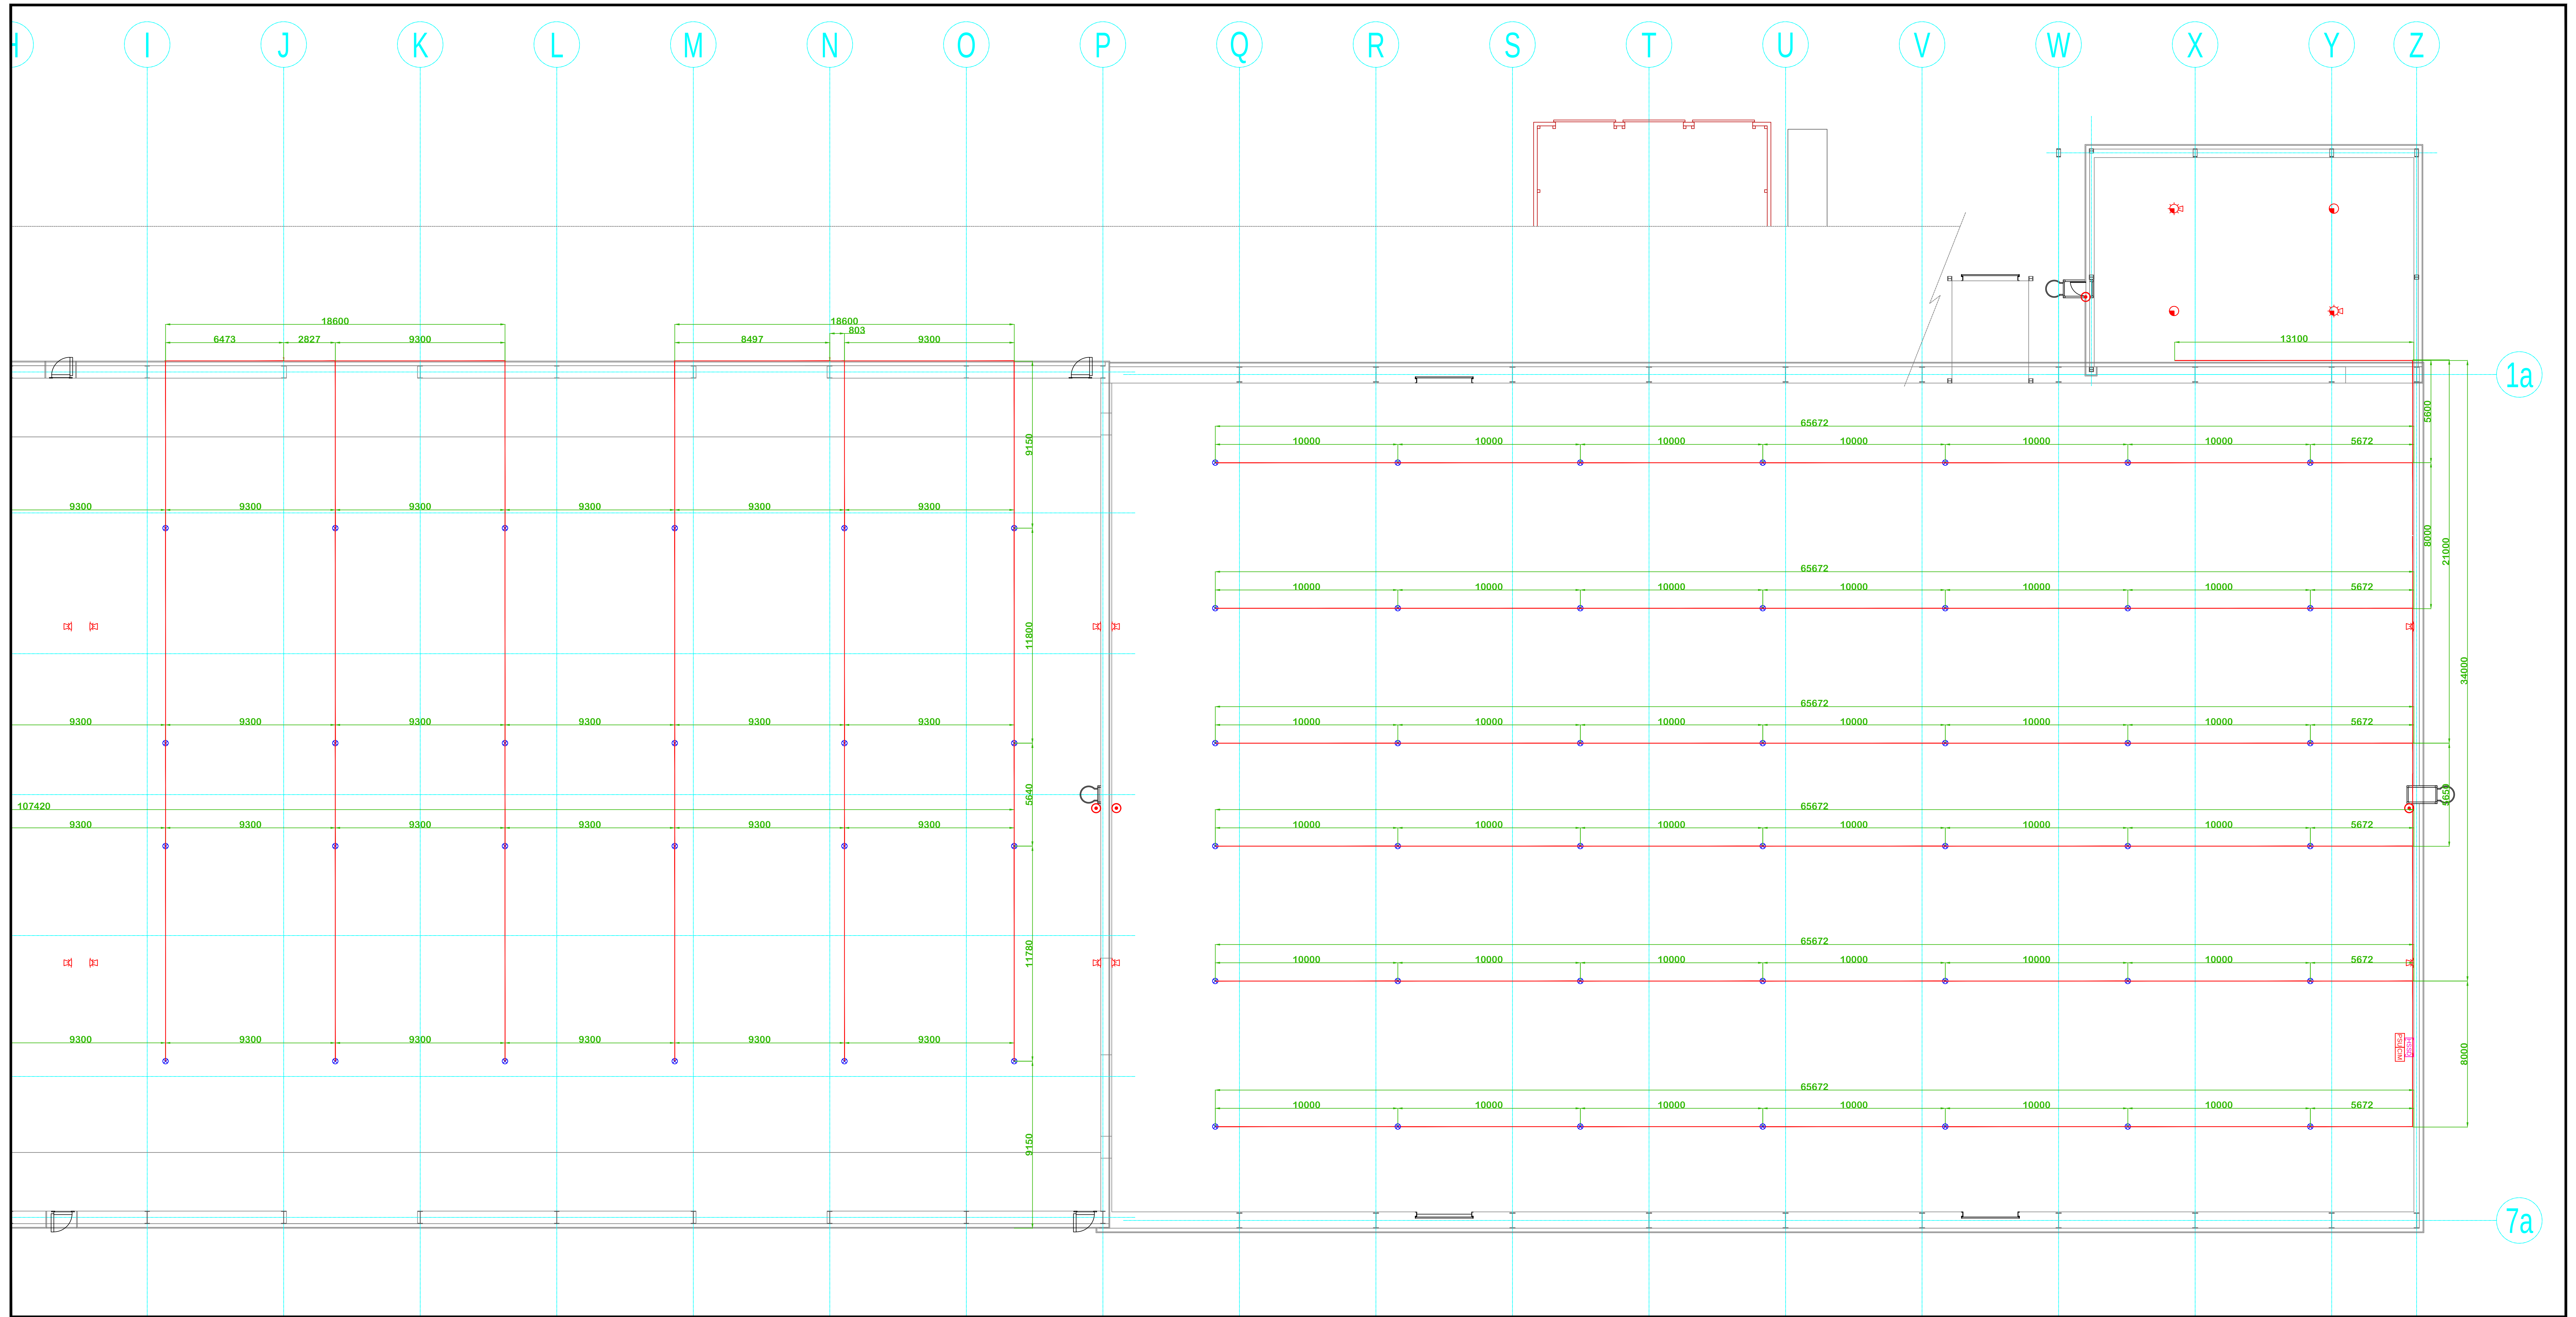

Fire Alarm

- CALLPOINT
- IONISATION SMOKE DETECTOR
- SMOKE DETECTOR
- FLAME DETECTOR
- CARBON DIOXIDE DETECTOR
- GAS DETECTOR
- HEAT DETECTOR

- COMBINED SMOKE DETECTOR/SOUNDER
- COMBINED HEAT DETECTOR/SOUNDER
- COMBINED SMOKE DETECTOR/SOUNDER/BEACON
- COMBINED HEAT DETECTOR/SOUNDER/BEACON
- COMBINED SMOKE DETECTOR/BEACON
- COMBINED HEAT DETECTOR/BEACON
- ALARM BELL

- ELECTRONIC SOUNDER
- ELECTRONIC SOUNDER WP - WEATHER PROOF
- COMBINED SMOKE DETECTOR/SOUNDER WITH LINE ISOLATOR
- FLASHING BEACON CEILING MOUNTED
- FLASHING BEACON WALL MOUNTED
- COMBINED BEACON/SOUNDER CEILING MOUNTED
- COMBINED BEACON/SOUNDER WALL MOUNTED

- L.E.D REMOTE INDICATOR
- LINE ISOLATOR
- CABLING JUNCTION BOX
- TEE BREAKER
- RELAY INTERFACE MODULE
- CONTACT INPUT MODULE
- DETECTOR INPUT MODULE

- SOUNDER NOTIFICATION MODULE
- SOUNDER CIRCUIT END OF LINE RESISTOR
- BEAM SMOKE DETECTOR AND ANALYSER
- BEAM REFLECTOR
- BEAM SMOKE DETECTOR TRANSMITTER
- 24v POWER SUPPLY UNIT
- MAIN FIRE CONTROL PANEL

- FIRE CONTROL REPEATER PANEL
- ELECTRICAL DISTRIBUTION BOARD
- HIGH SENSITIVITY SMOKE DETECTION CONTROL UNIT (VESDA)
- MAGNETIC DOOR HOLDER
- OVER DOOR HOLDER/CLOSURE

NOTES:



4 HERMITAGE CLOSE
THREE LEGGED CROSS
WIMBORNE
DORSET
BH21 1QA
Tel: 07835 742300
Email: autocad_drawings@lifesystems.net


Revision	Description	Date	Checked
AMENDMENT RECORD			

Project:
ABP - Canary Fruit Terminal
Berth 103 & 104
Western Docks
Southampton
Hampshire

Title:
New Tomato Warehouse / Shed
Proposed
Fire Alarm System
ROOF VOID
(Sheet 2 of 2)

Drawn By: ISW
Checked By:
Scale @ A0: 1:125
Date: AUG 16

 Drawing Number:
SAMPLE/2016/08/FA112
Revision:



NOTES:



4 HERMITAGE CLOSE
THREE LEGGED CROSS
WIMBORNE
DORSET
BH21 6QA
Tel: 07835 742300
Email: autocad_drawings@btinternet.com

Revision	Description	Date	Checked
AMENDMENT RECORD			

Project:
**ABP - Canary Fruit Terminal
Berth 103 & 104
Western Docks
Southampton
Hampshire**

Title:

**New Tomato Warehouse / Shed
Proposed
Fire Alarm System**

**103 ROOF VOID & PACKING
ASPIRATING DETECTION SYSTEM
ISOMETRIC SAMPLING PIPE LAYOUT**

Drawn By:	ISW
Checked By:	
Scale @ A0:	1:125

Date:	AUG 16
Date:	
Date:	AUG 16

© This drawing and/or design is the property of LIFE SAFETY SYSTEMS[®] and shall not be reproduced or copied in the whole or part in any way or conveyed to a third party without the owners written permission.

Drawing Number:

SAMPLE/2016/08/FA201

Revision:

--	--	--	--	--	--	--	--

