


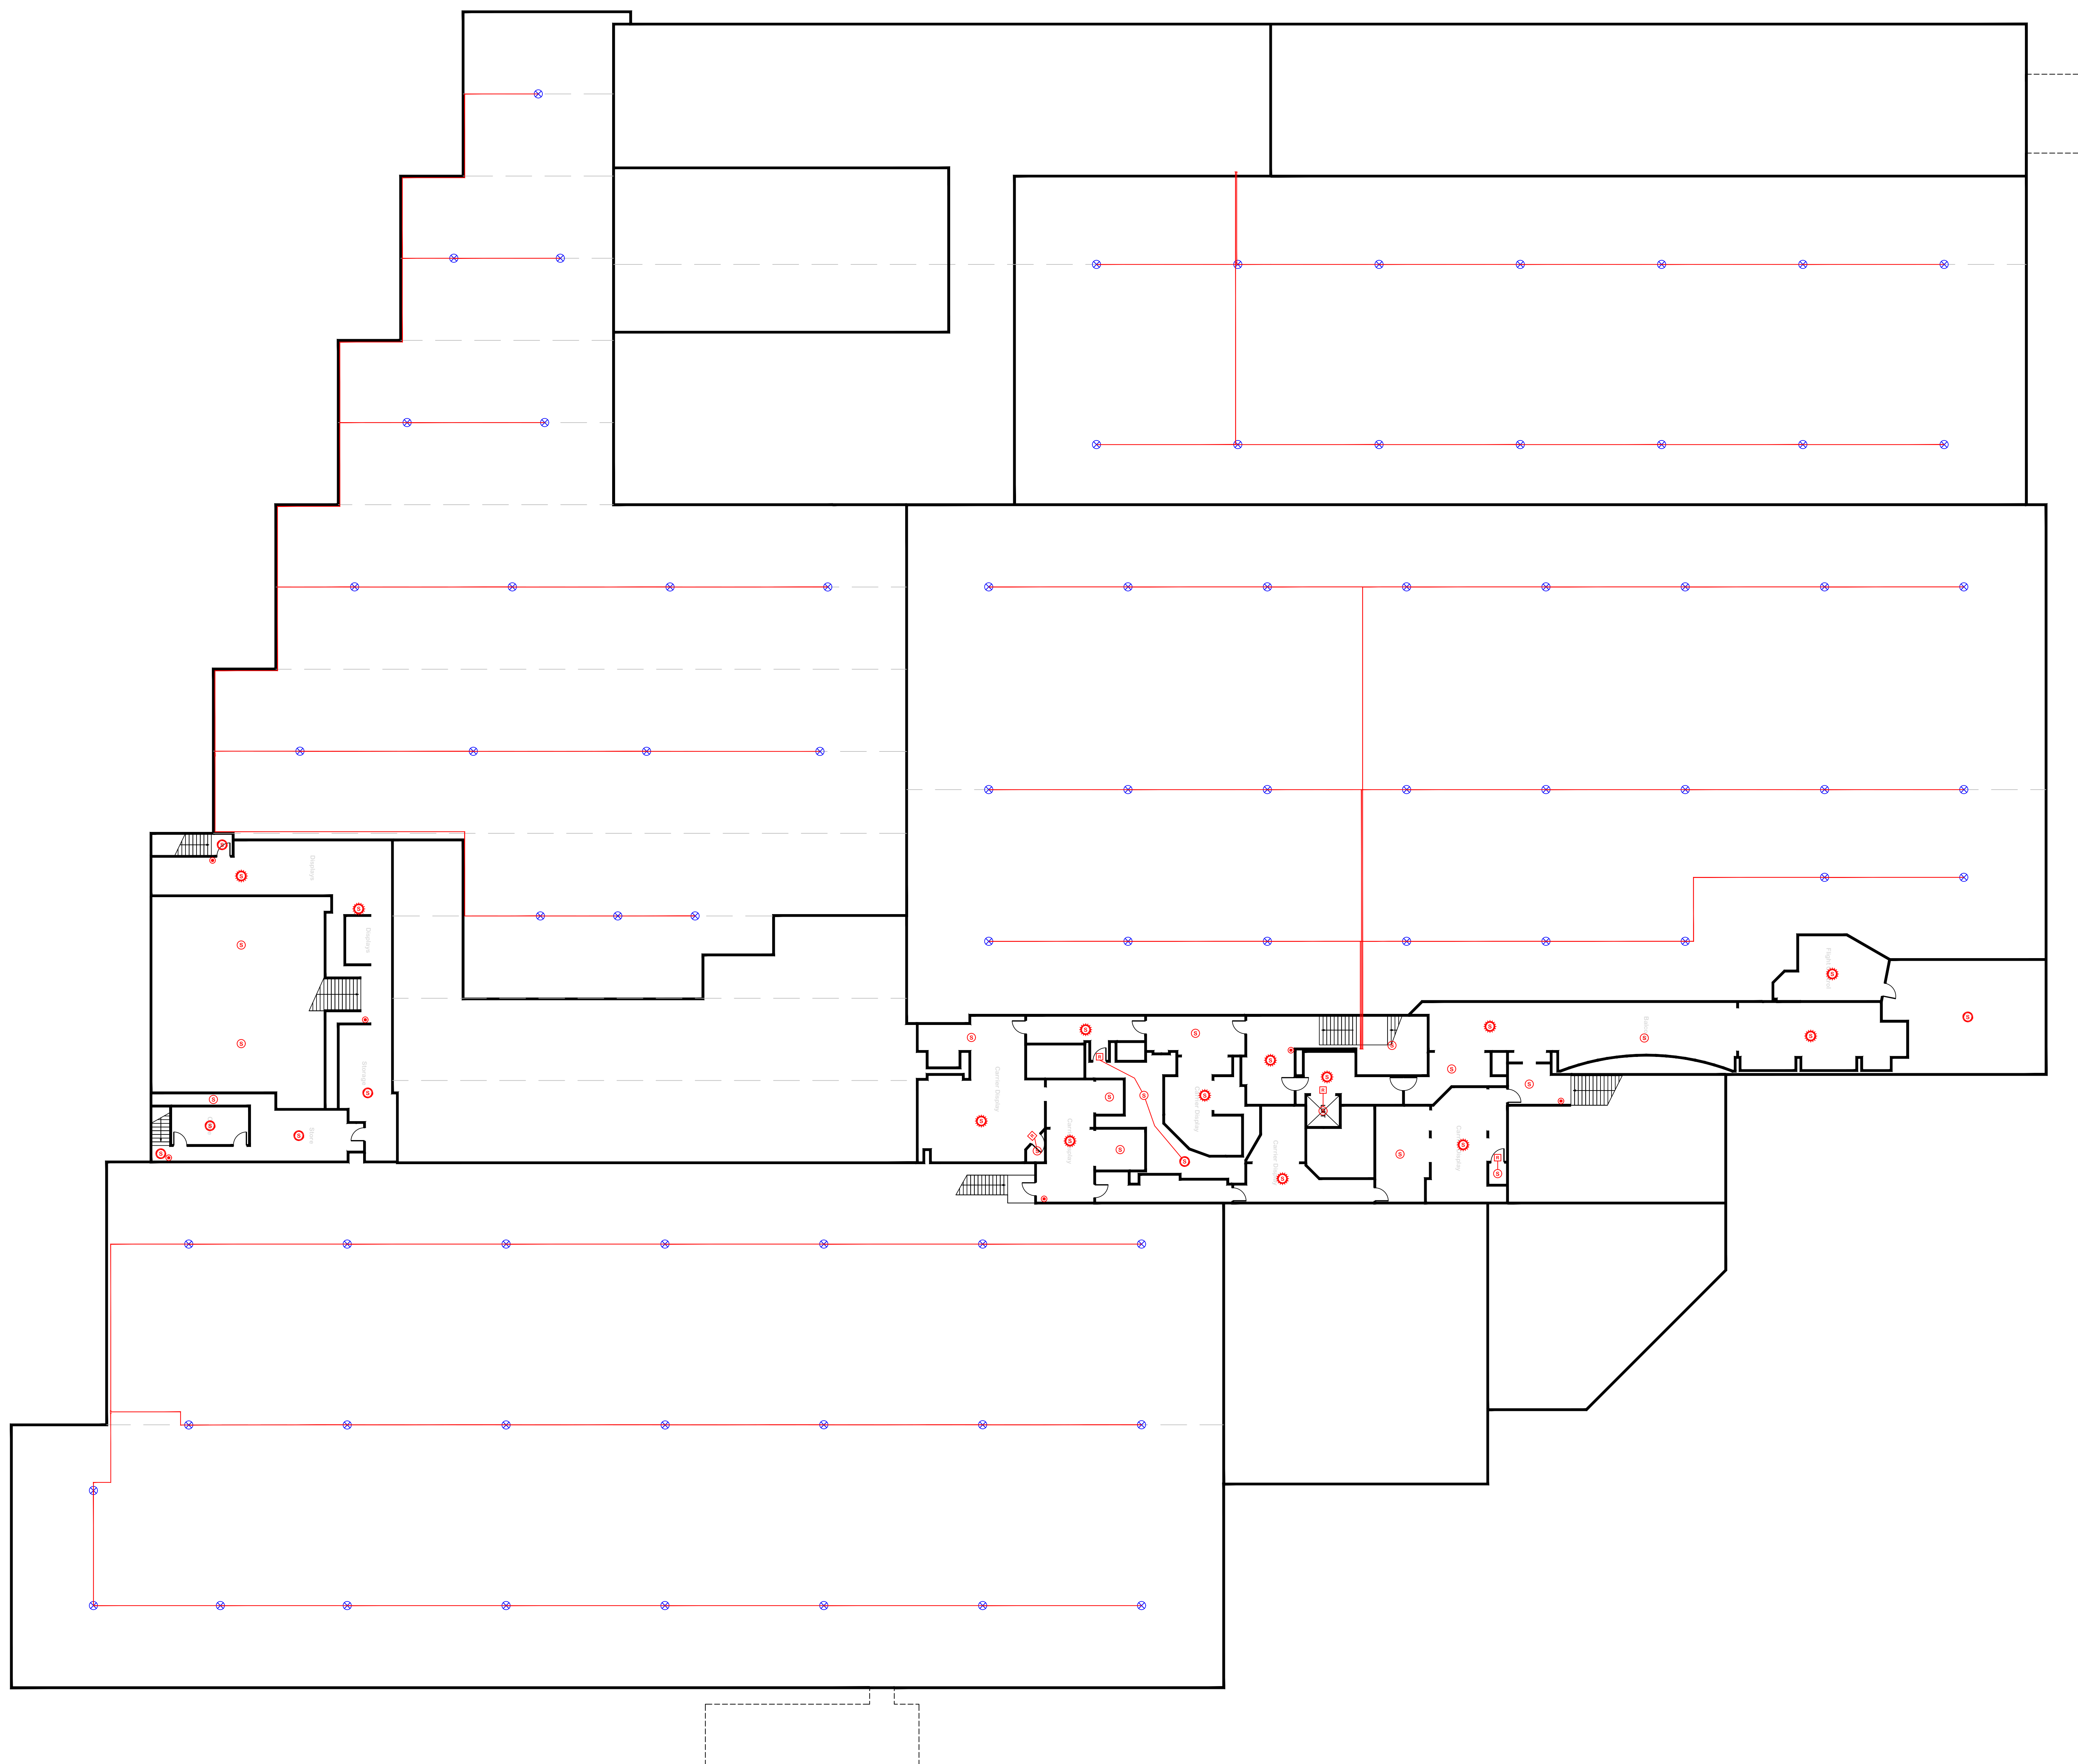

The building layout as depicted on this drawing have been extrapolated from copies of original (Small Scale) "Paper Drawings", as a consequence the layout as shown may not be completely accurate or up to date.

NOTE

NOTES: **Fire Alarm**

- | | |
|---|---|
|  | Indicator Control Panel |
|  | Repeater Indicator Control Panel |
|  | Smoke Detector/Sensor |
|  | Heat Detector/Sensor |
|  | Combined Smoke/Heat Detector/Sensor |
|  | Detector/Sensor Mounted Base Sounder |
|  | Detector/Sensor Base Sounder/Beacon |
|  | Manual Call Point |
|  | Alarm Sounder |
|  | Combined Sounder/Beacon |
|  | Beacon |
|  | Alarm Bell |
|  | Sensor/Detector Remote Visual Indicator |
|  | Interface (Letter Denotes Type) |
|  | Miscellaneous Unit/Interface |
|  | Beam Detector Transmitter Unit |
|  | Beam Detector Receiver Unit |

Revision	Description	Date	Checked

AMENDMENT RECORD



Project:
Fleet Air Arm Museum
RNAS Yeovilton
Ilchester
Somerset
BA22 8HT

Title:

**Provisional Design Concept
Fire Alarm System
Upgrade & Replacement**

SECOND FLOOR


Drawn By: ISW	Date: NOV 11
-------------------------	------------------------

Checked By:	Date:
-------------	-------


Scale @ A0: 1:150 (Appox)	Date: NOV 15
-------------------------------------	------------------------

Drawing Number:
SAMPLE/2011/11/FA120


Revision:								
-----------	--	--	--	--	--	--	--	--

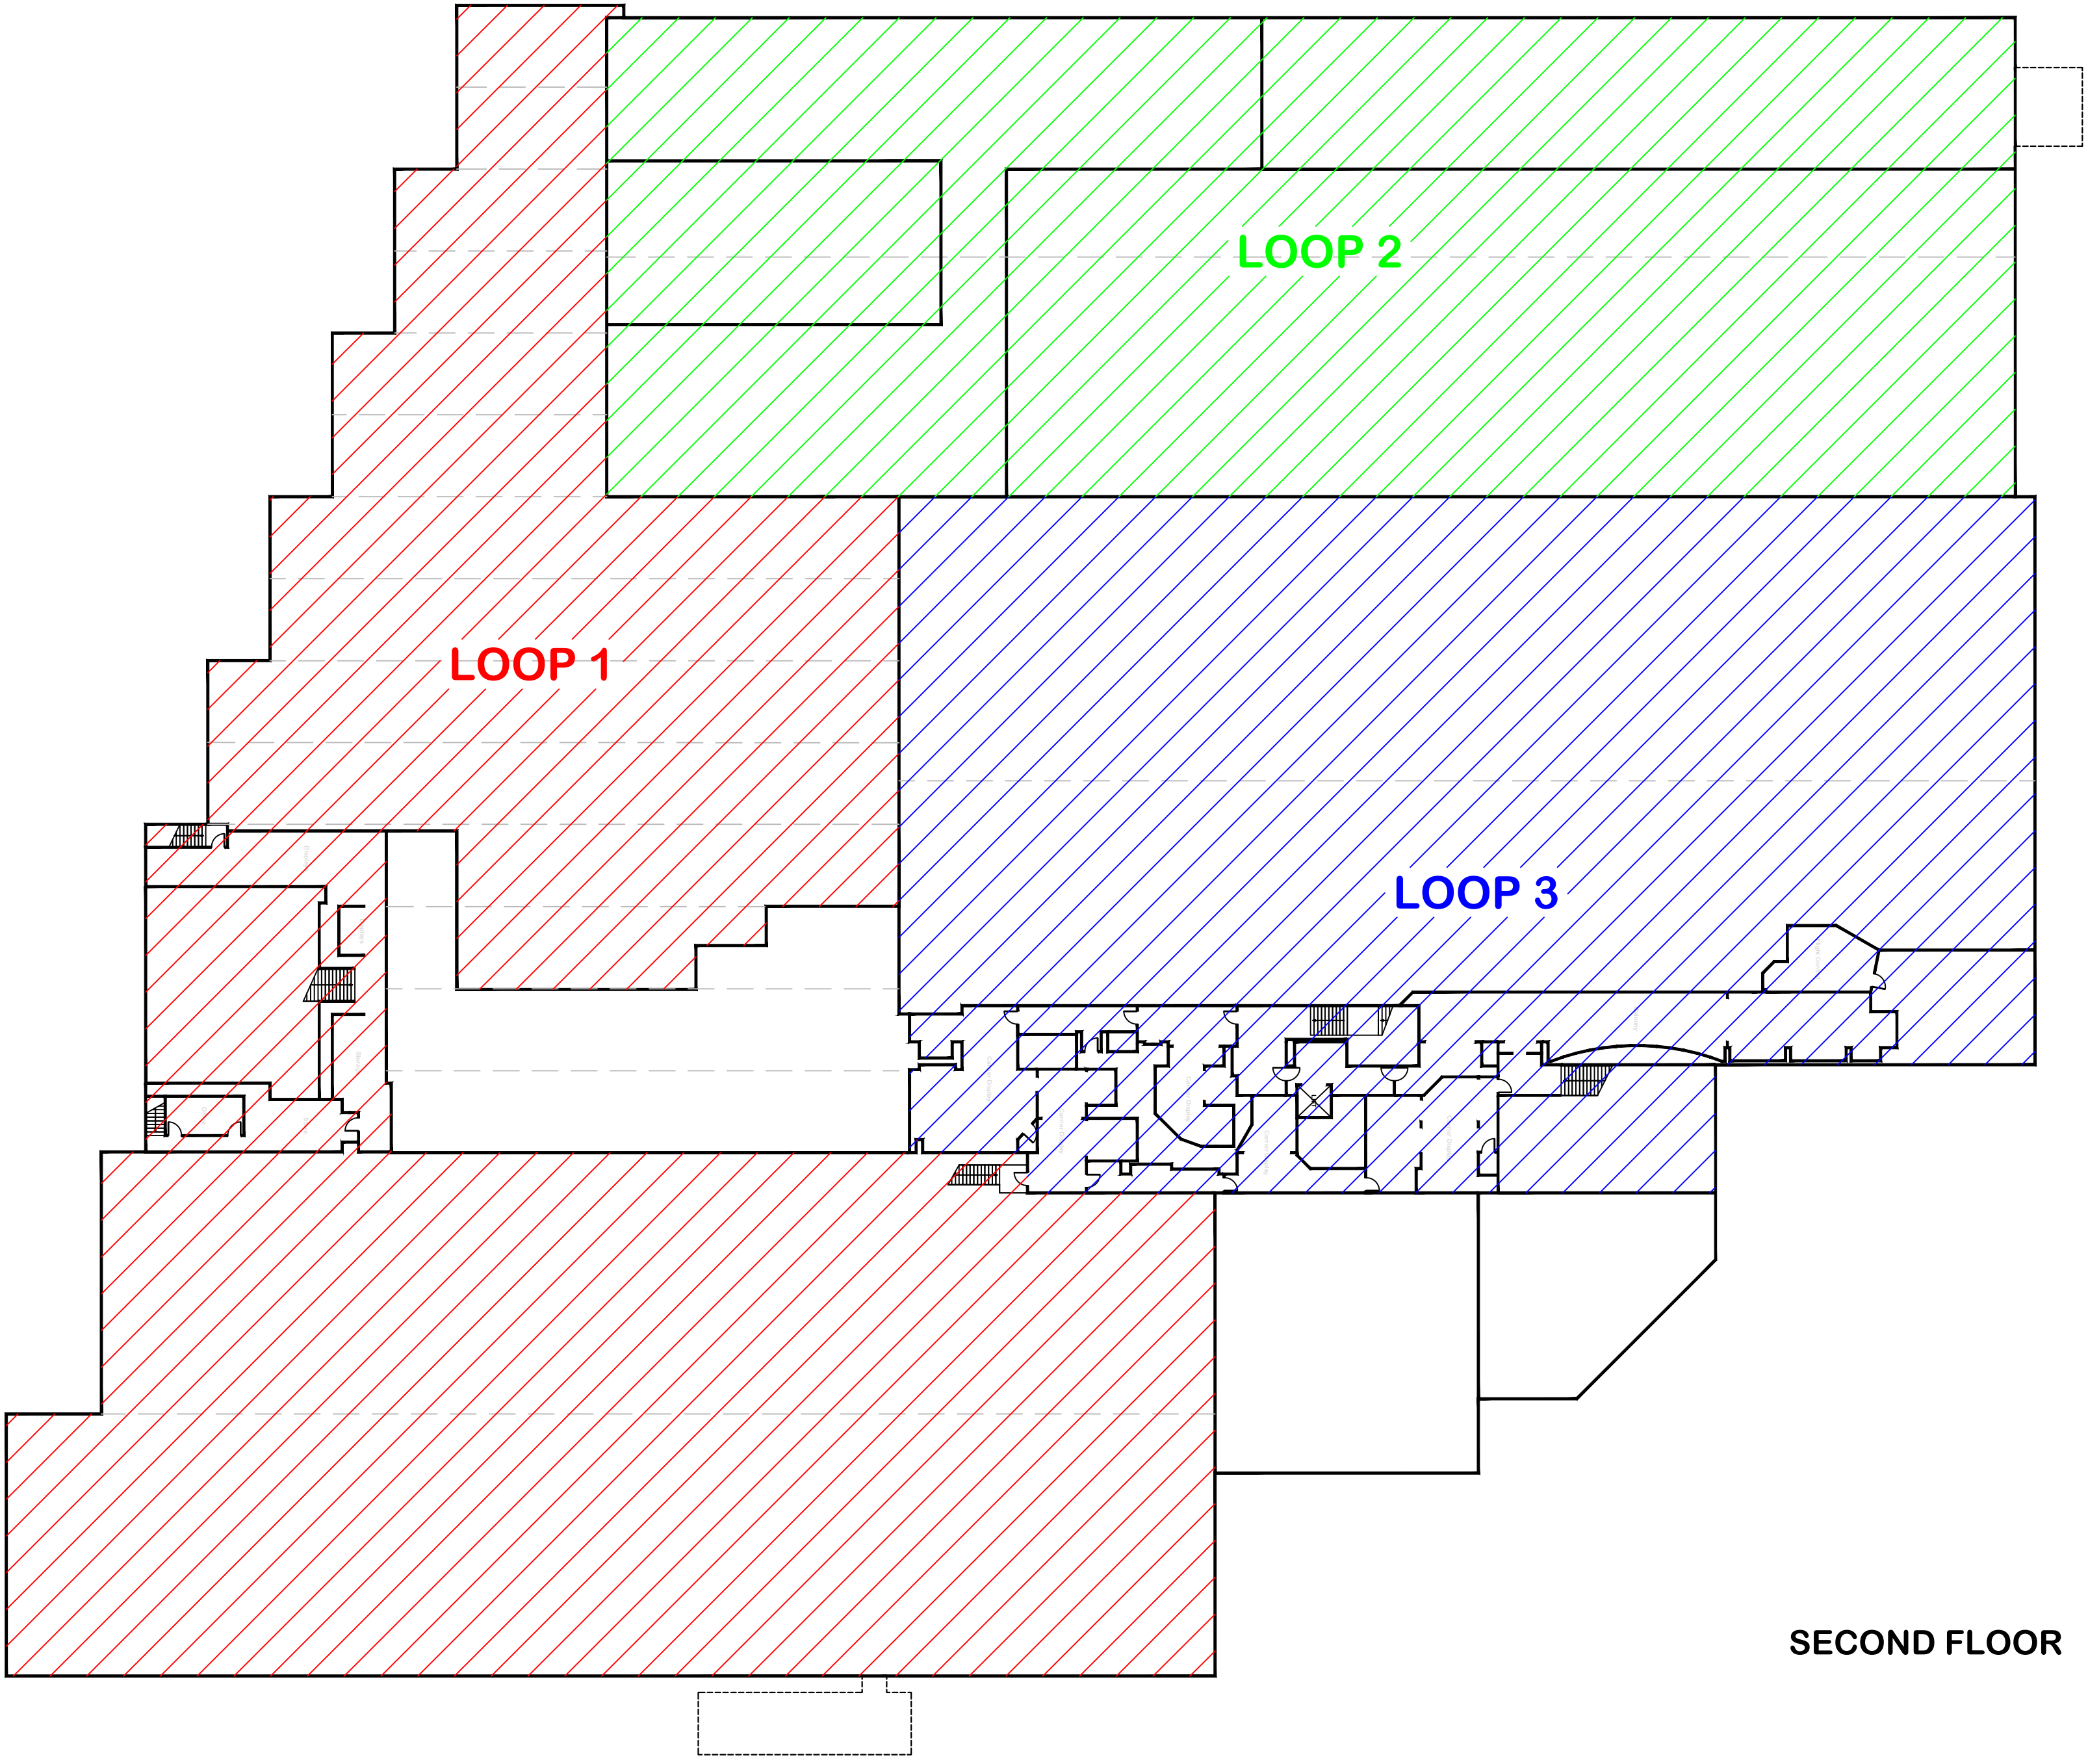

SECOND FLOOR

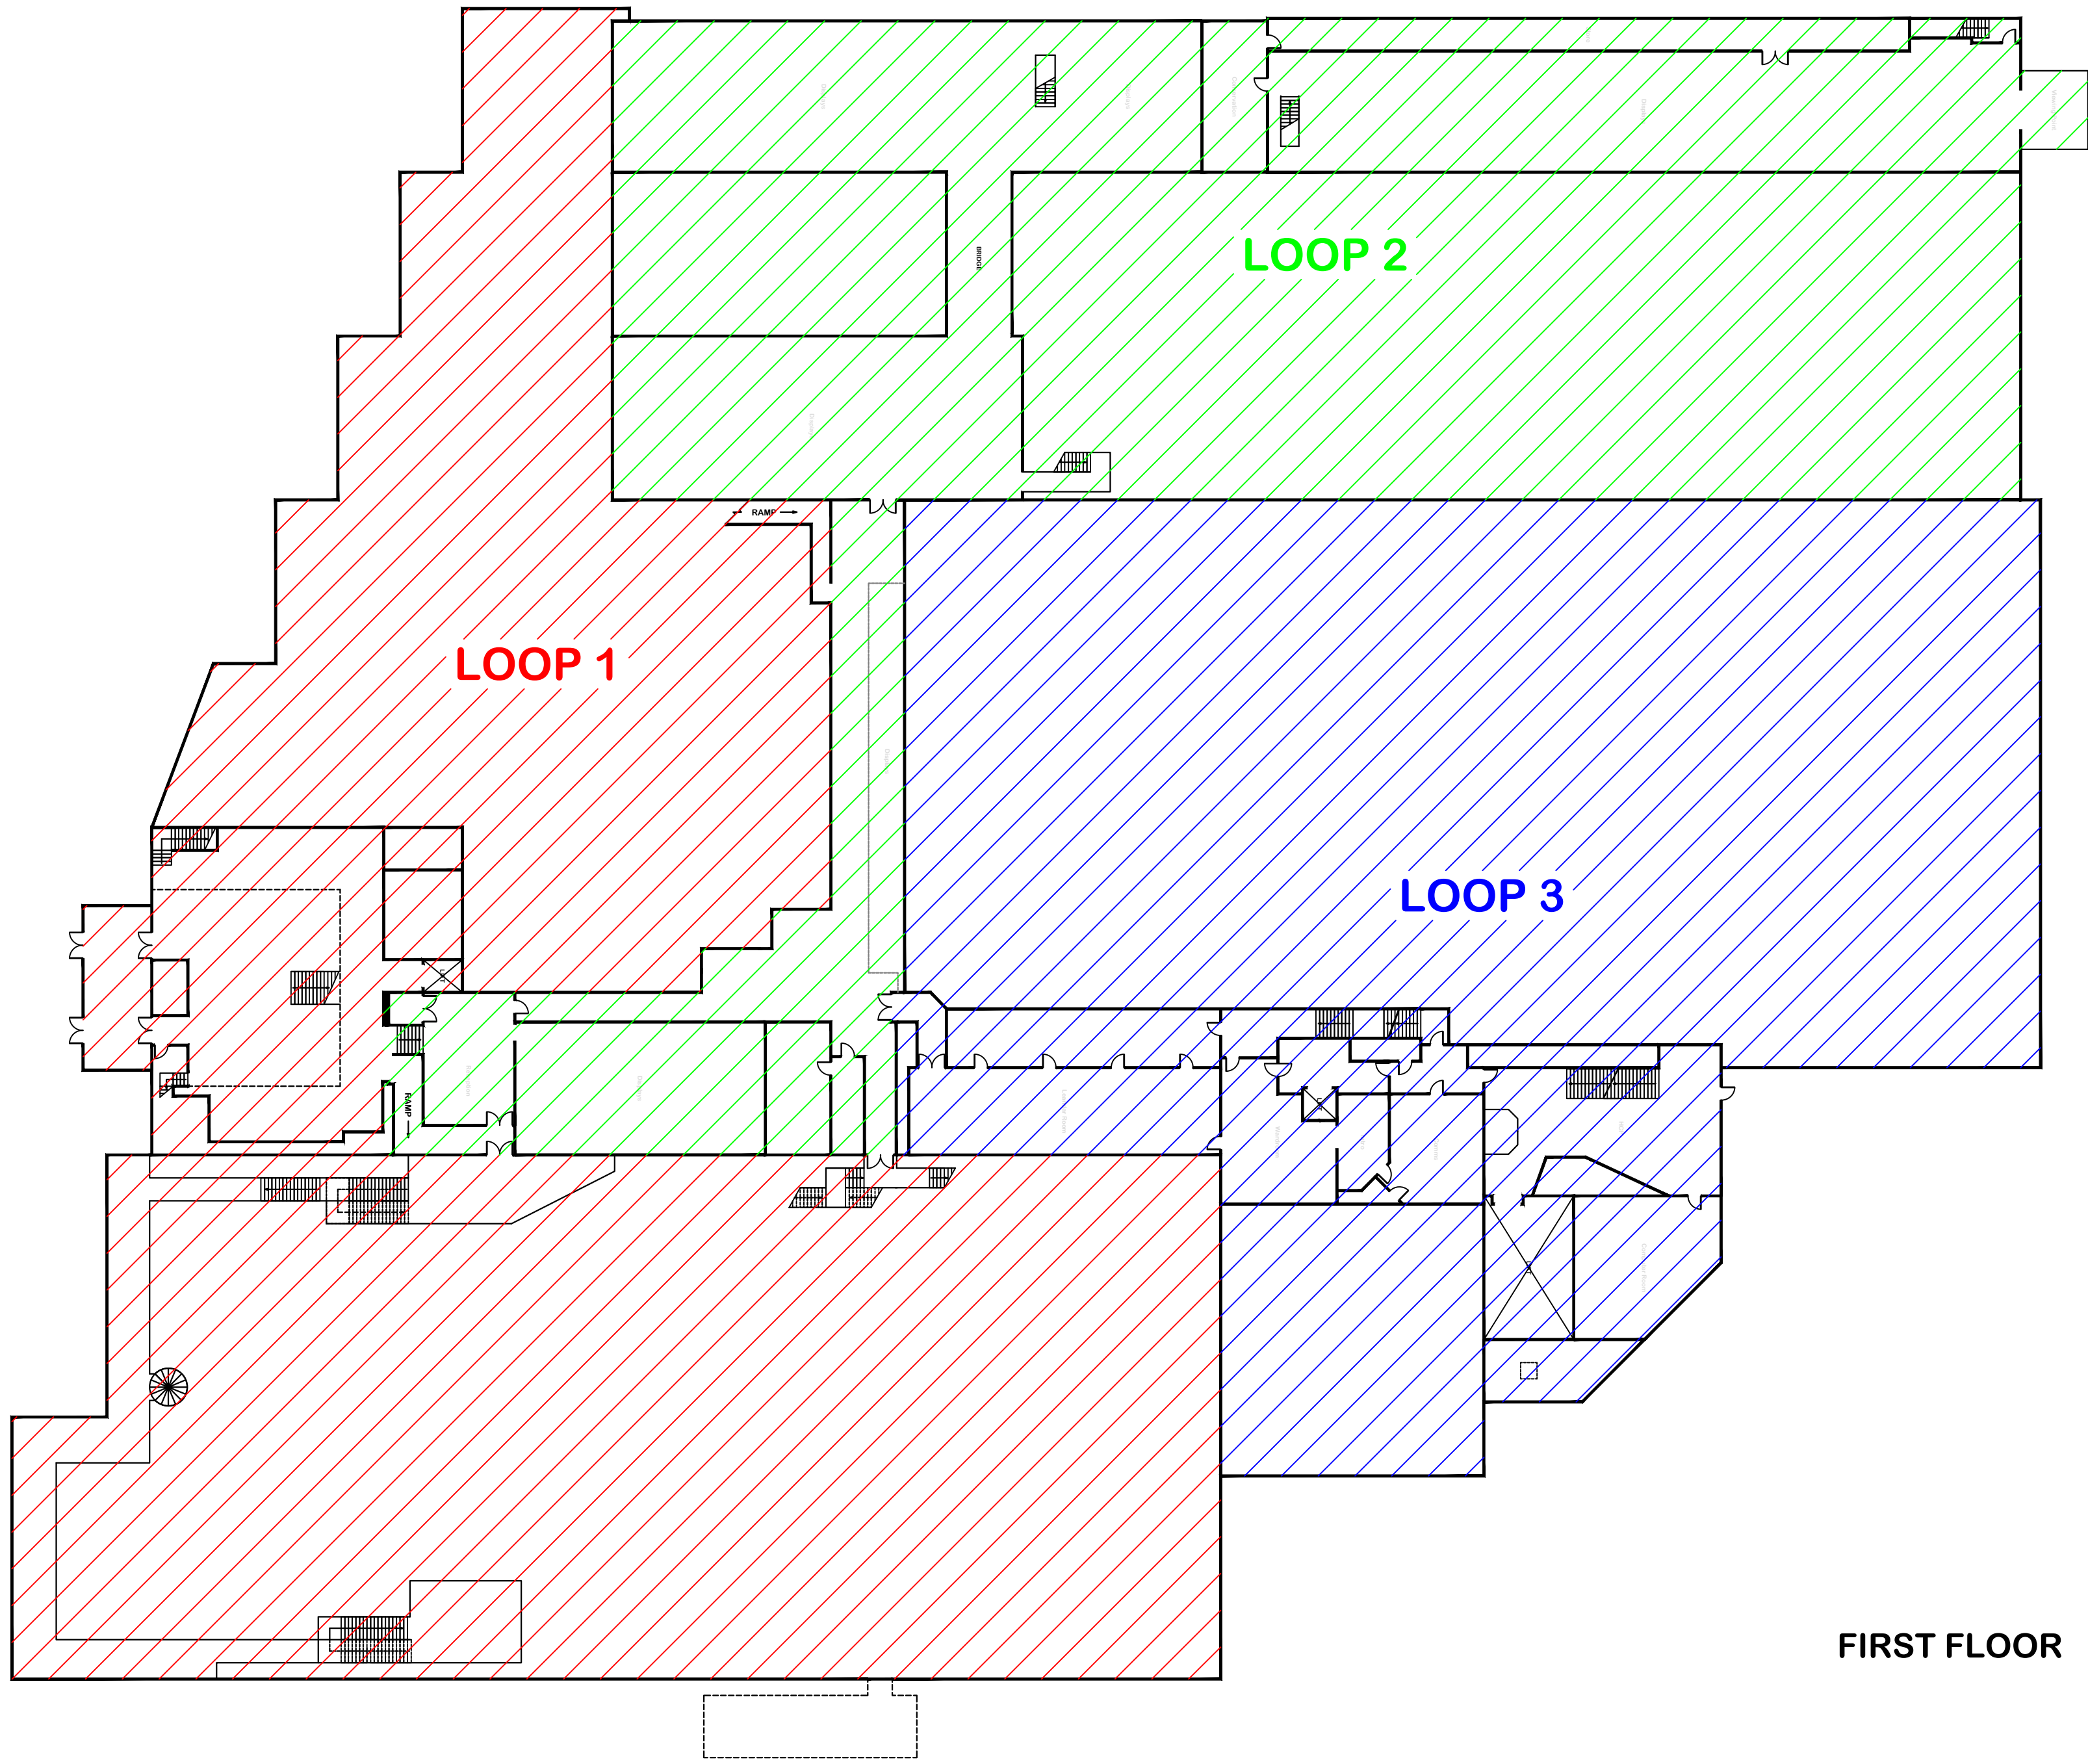

FIRST FLOOR

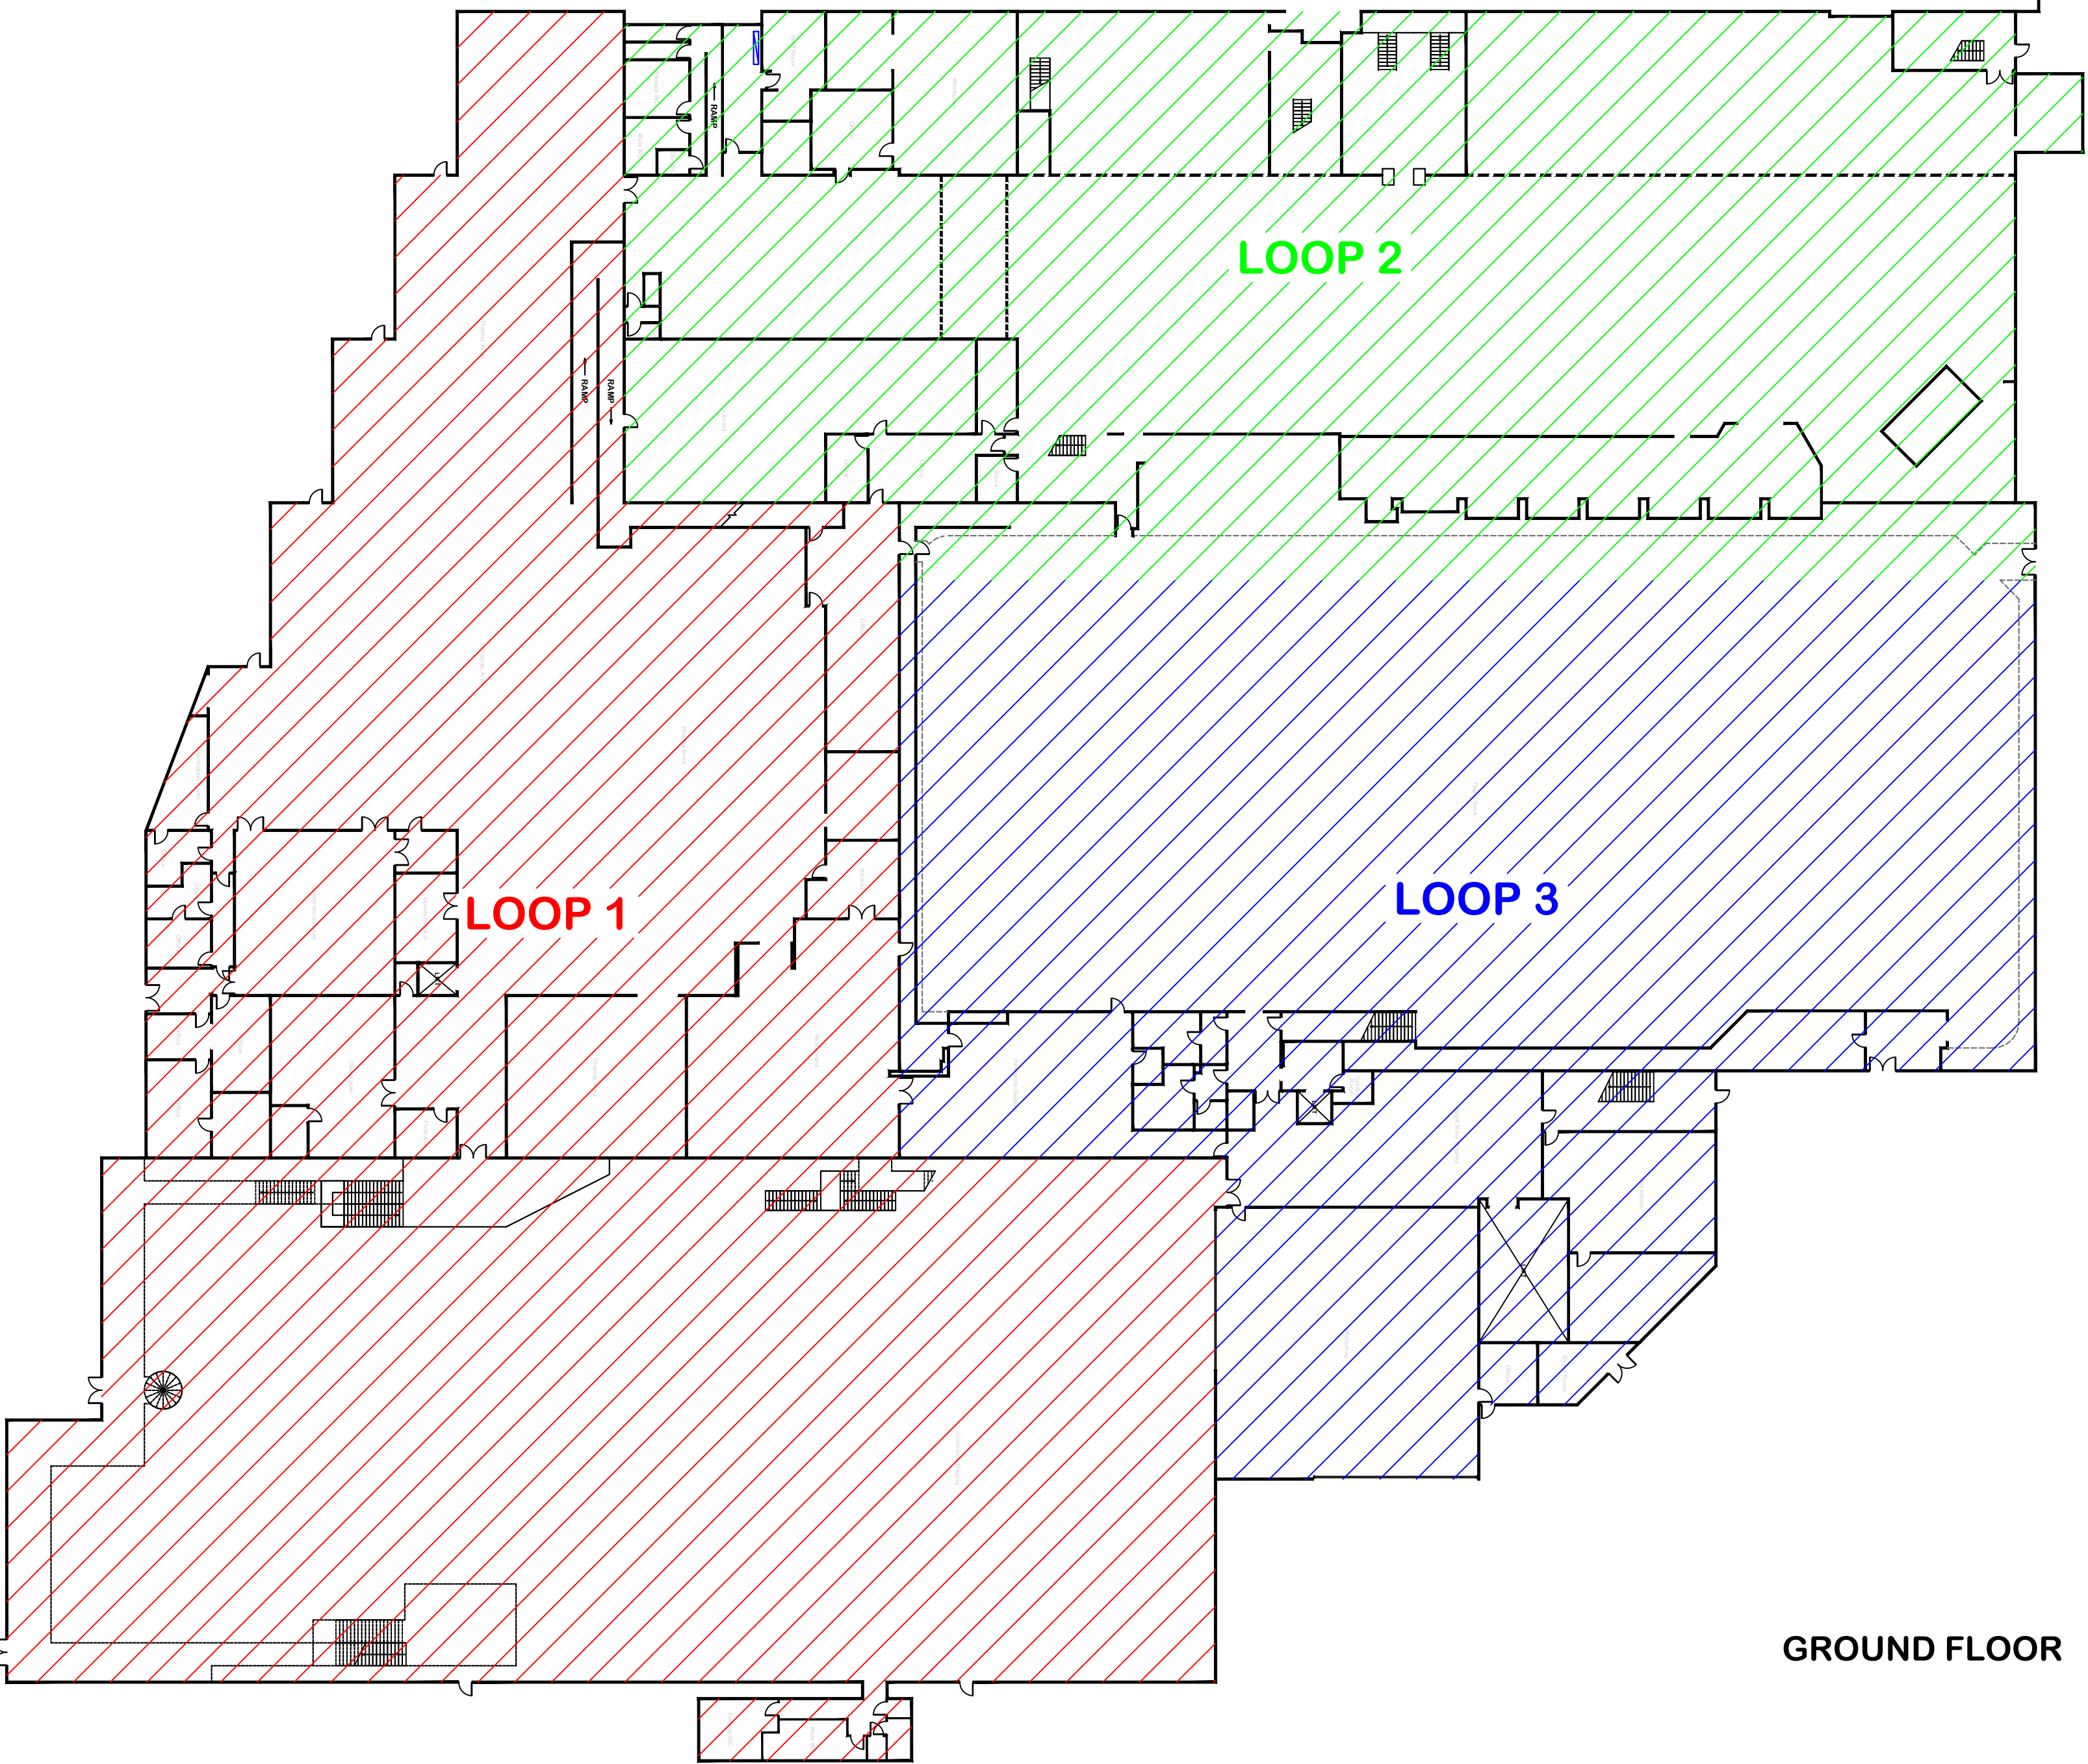

GROUND FLOOR

NOTES:
The building layout as depicted on this drawing have been extrapolated from copies of original (Small Scale) "Paper Drawings", as a consequence the layout as shown may not be completely accurate or up to date.



4 HERMAGE CLOSE
THREE LEGGED CROSS
WIMBORNE
DORSET
BH21 3JA
Tel: 07835 742300
Email: support_drawings@lifesystems.com

Project:
Fleet Air Arm Museum
RNAS Yeovilton
Ilchester
Somerset
BA22 8HT

Title:
Provisional Design Concept
Fire Alarm System
Upgrade & Replacement
Proposed Loop Configurations

Drawn By:
ISW

Date:
NOV 11

Checked By:

Date:

Scale @ A0:

1:300 (Approx)


Date:

NOV 11


Revision	Description	Date	Checked
AMENDMENT RECORD			
© This drawing and/or design is the property of "LIFE SAFETY SYSTEMS" and shall not be reproduced or copied in the whole or part in any way or conveyed to a third party without the owners written permission.			
Drawing Number: SAMPLE/2011/11/FA200			
Revision:			

Fire Alarm

- CALLPOINT
- SMOKE DETECTOR
- HEAT DETECTOR
- COMBINED SMOKE DETECTOR/SOUNDER
- COMBINED HEAT DETECTOR/SOUNDER
- COMBINED SMOKE DETECTOR/SOUNDER/BEACON
- COMBINED HEAT DETECTOR/SOUNDER/BEACON
- COMBINED SMOKE DETECTOR/BEACON
- COMBINED BEACON/SOUNDER WALL MOUNTED
- MAIN FIRE CONTROL PANEL

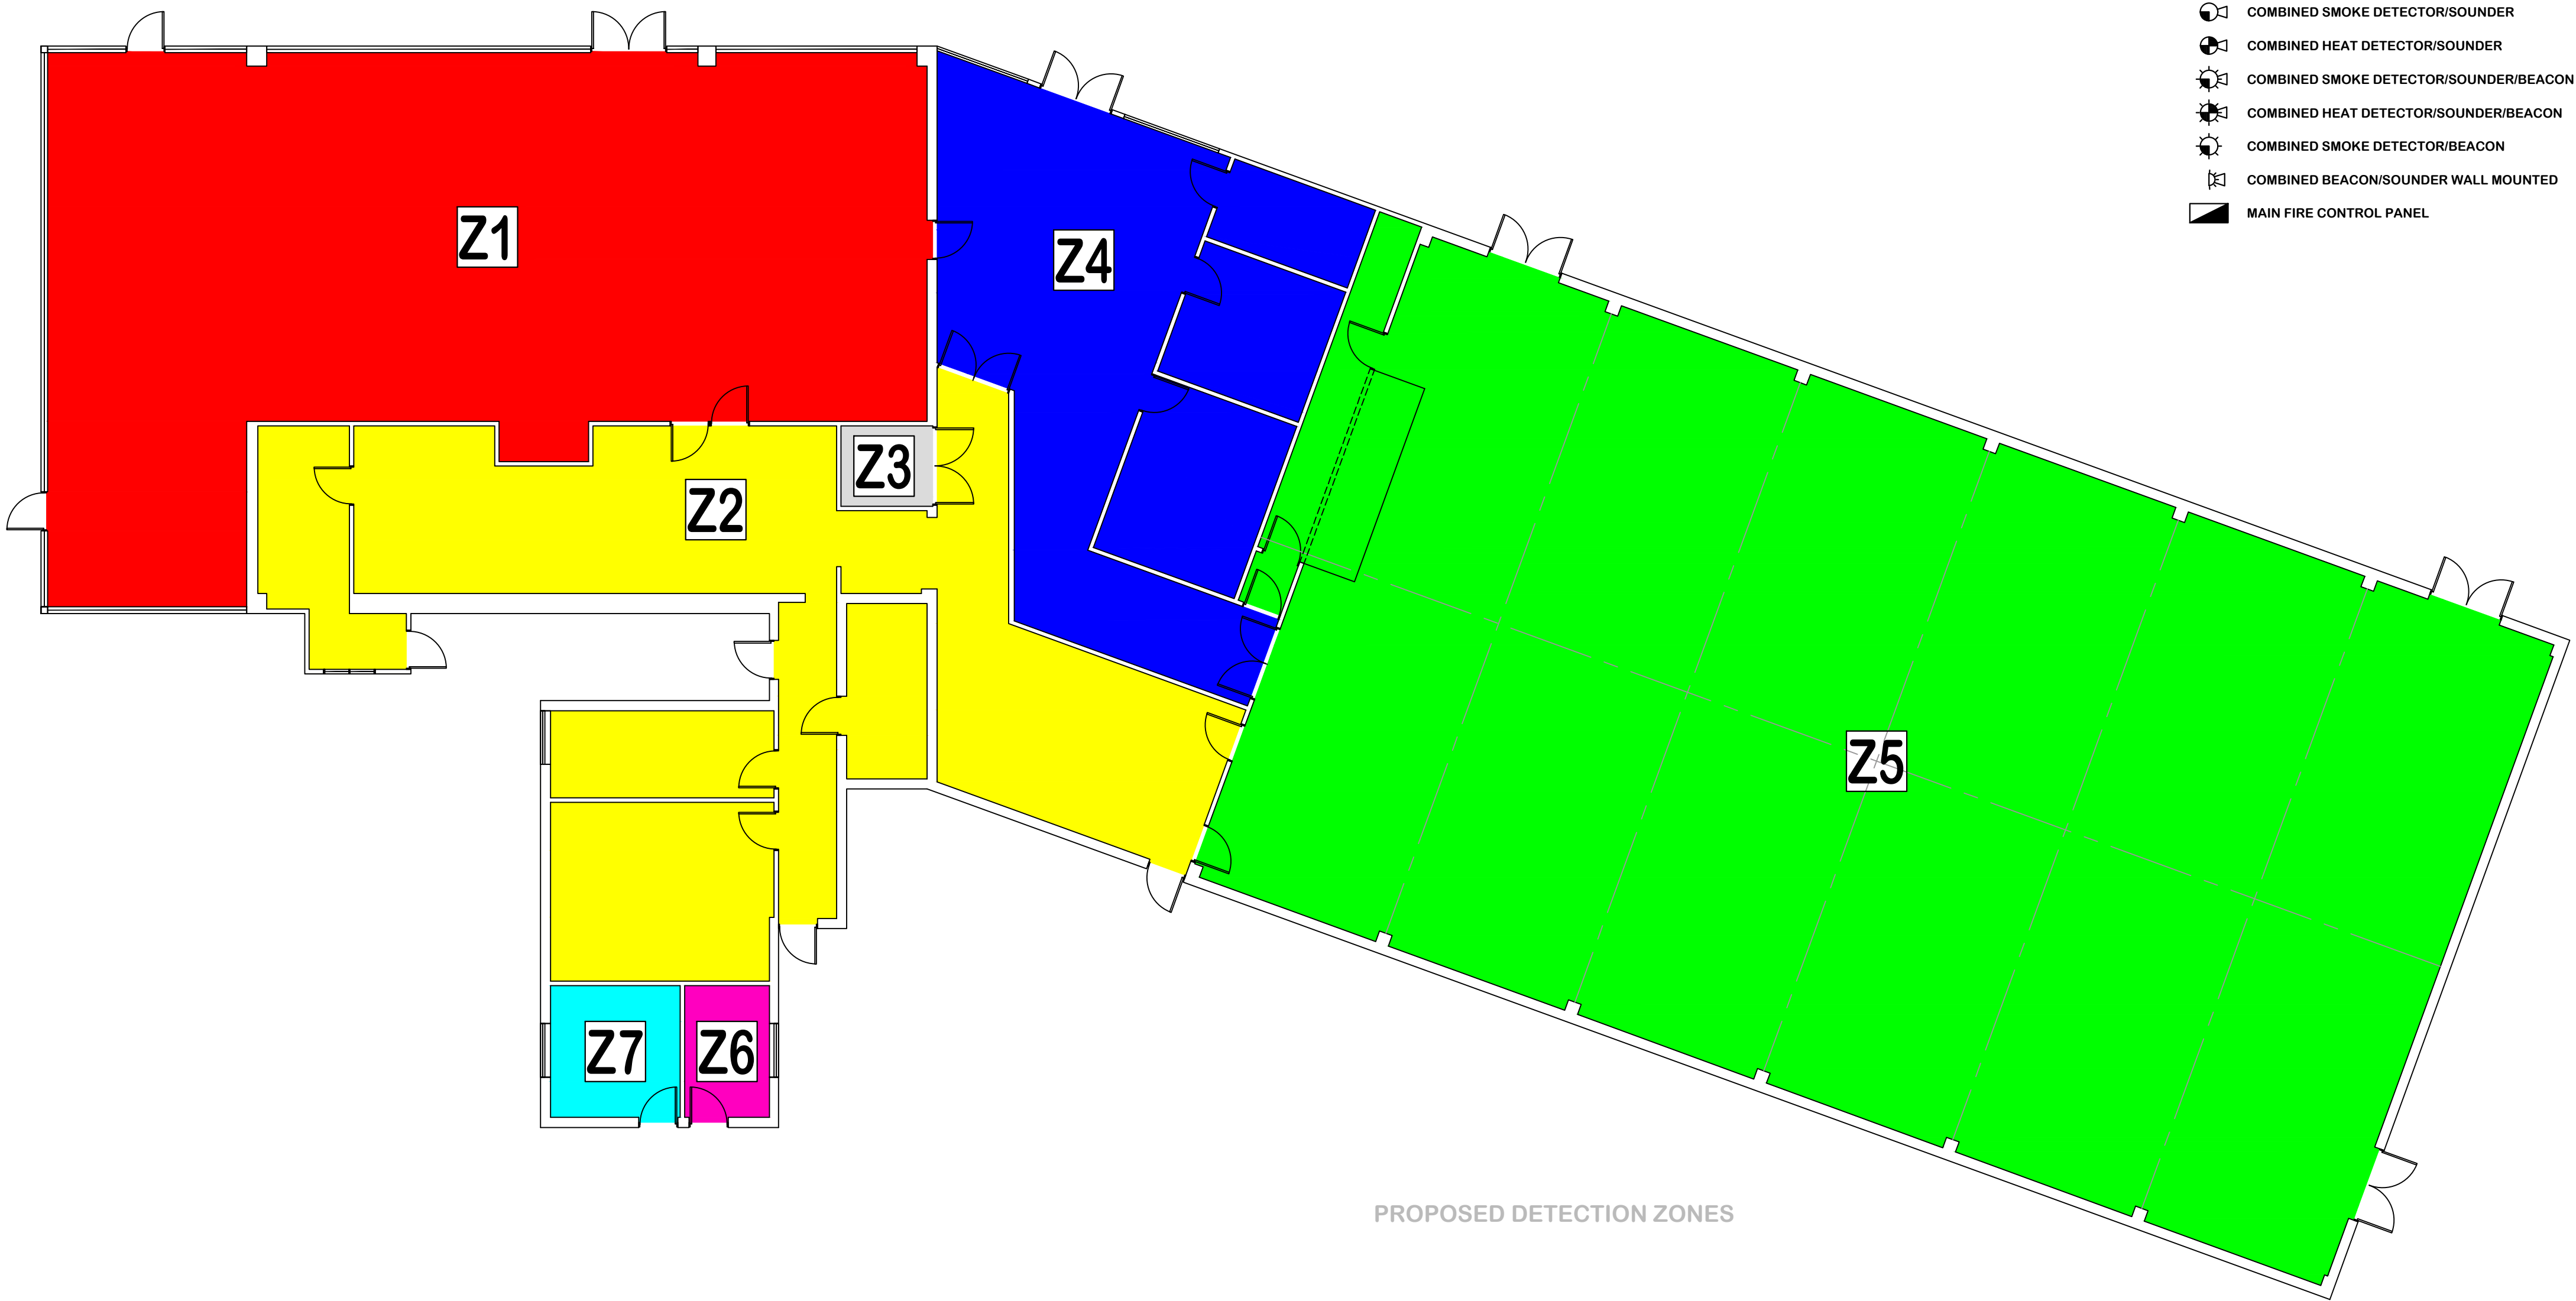

PROPOSED DETECTION ZONES

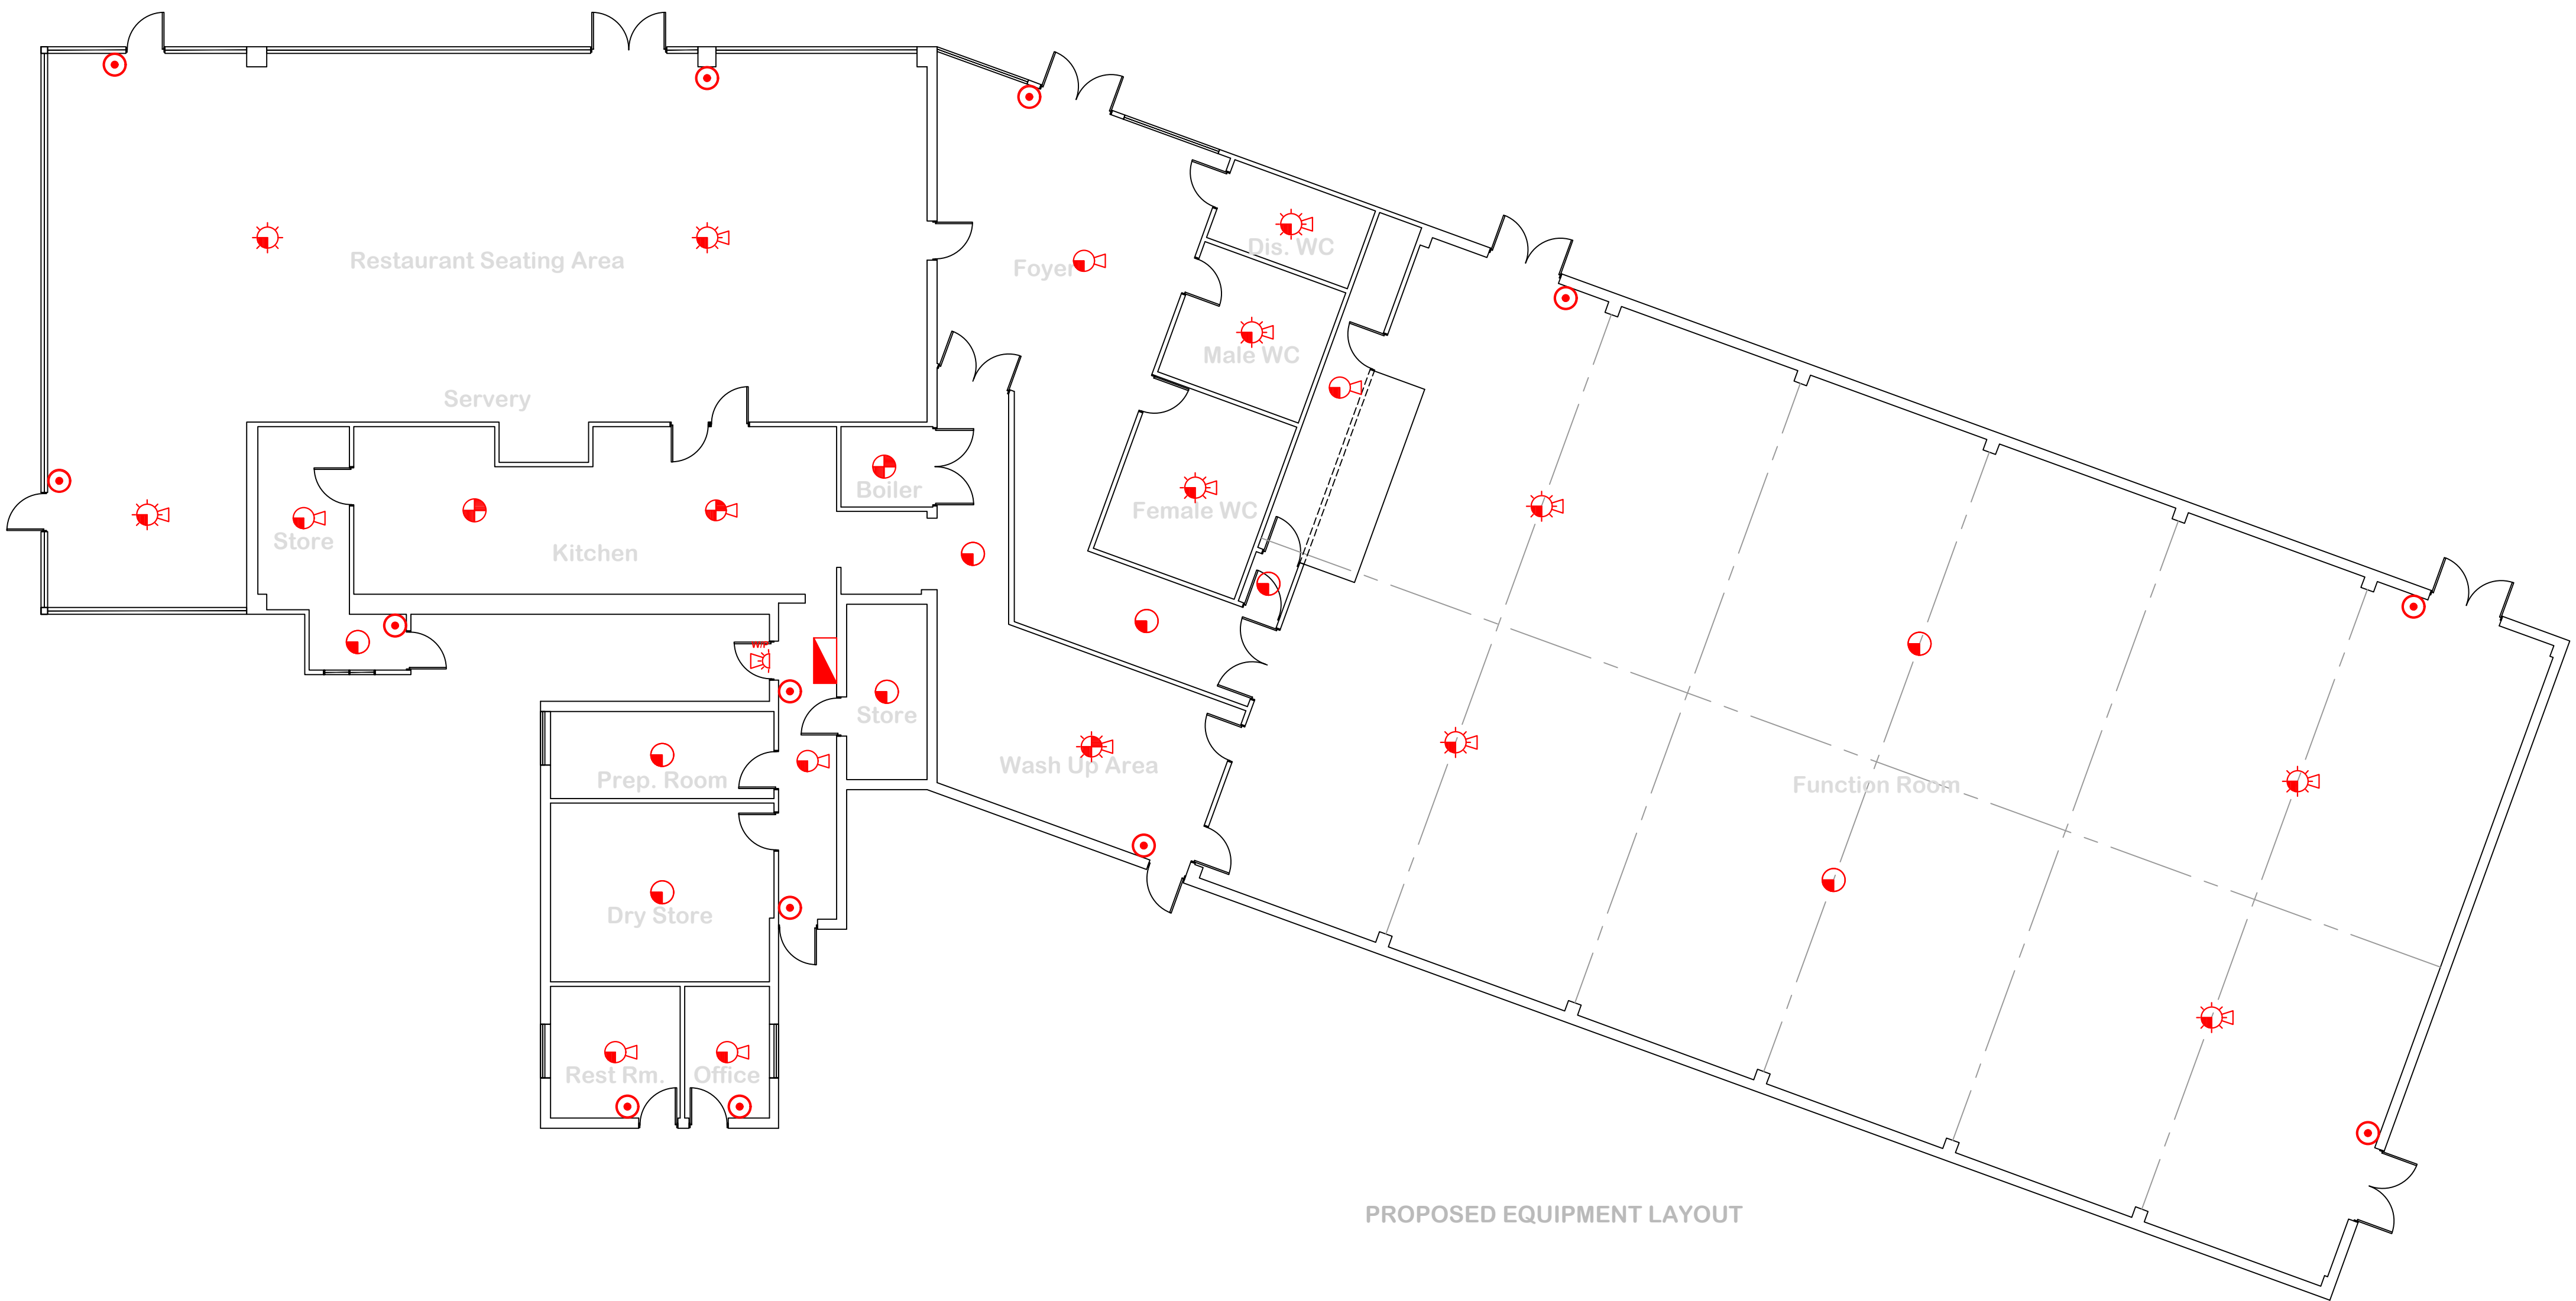

PROPOSED EQUIPMENT LAYOUT

Revision	Description	Date	Checked
AMENDMENT RECORD			
© This drawing and/or design is the property of 'LIFE SAFETY SYSTEMS' and shall not be reproduced or copied in the whole or part in any way or conveyed to a third party without the owners written permission.			
Drawing Number:			
SAMPLE/2018/05/FA300			
Revision:			